


COW BARN WAY

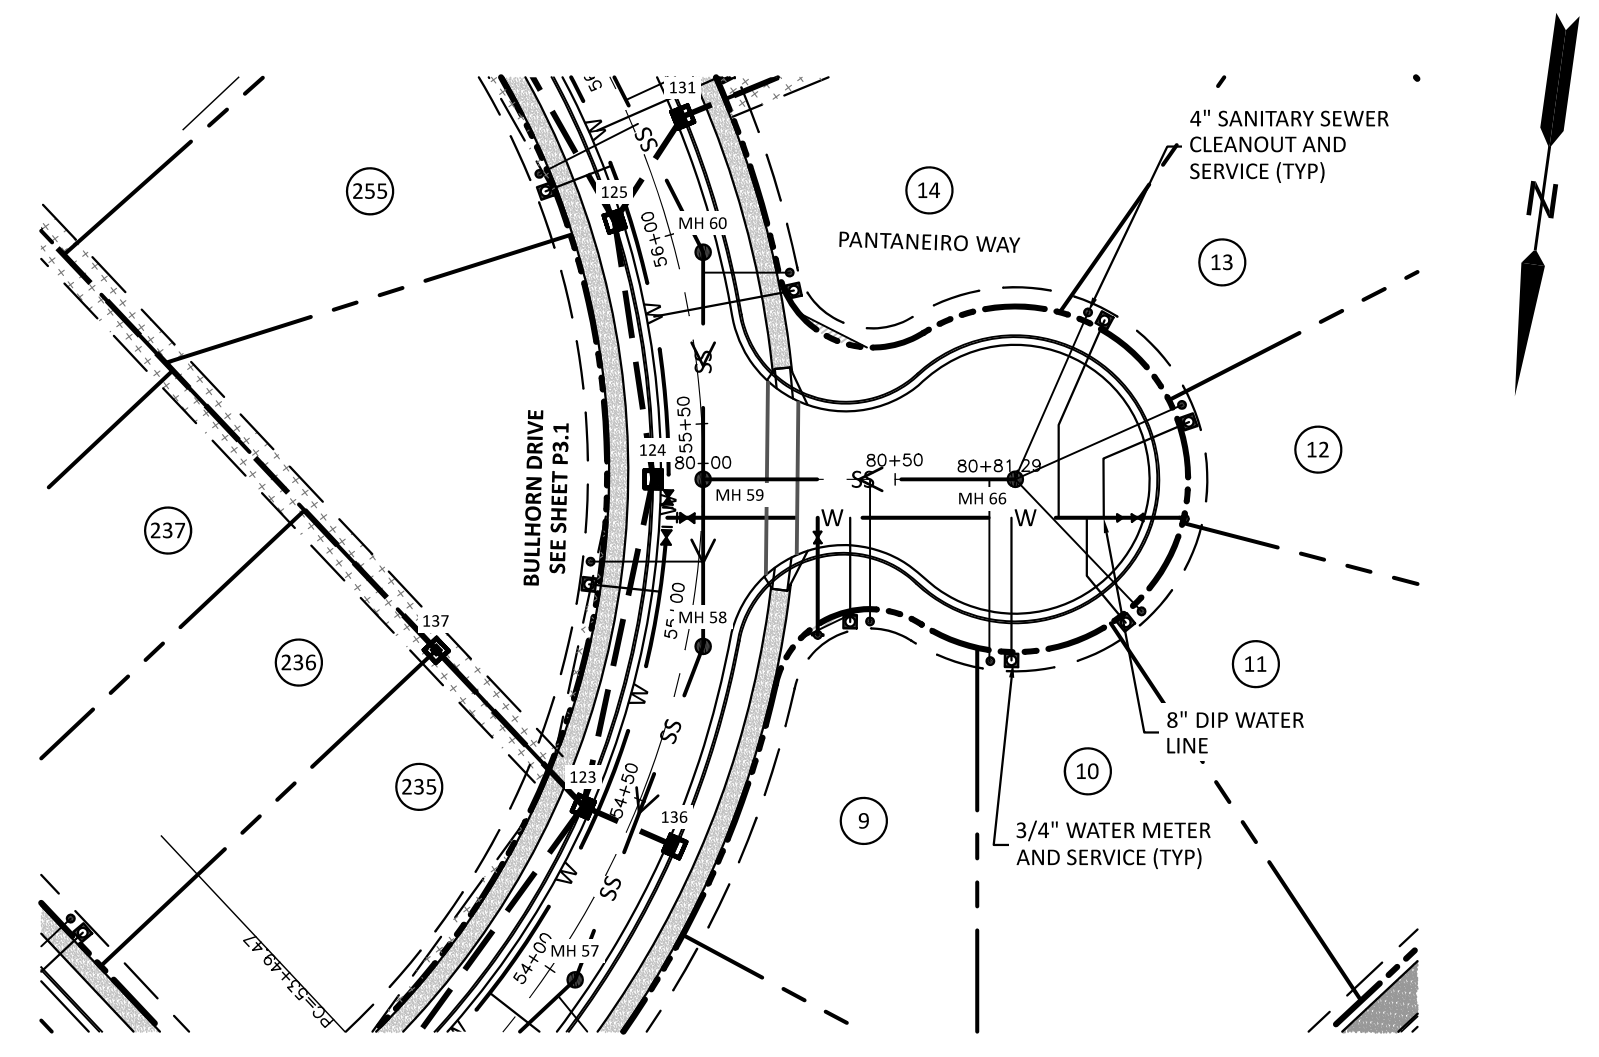



PANTANIERO WAY

ATTENTION CONTRACTORS
 THE CONSTRUCTION CONTRACTOR RESPONSIBLE FOR THE EXTENSION OF WATER, SEWER AND/OR REUSE, AS APPROVED IN THESE PLANS, IS RESPONSIBLE FOR CONTACTING THE PUBLIC UTILITIES DEPARTMENT AT 919-296-4540 AT LEAST 24 HOURS PRIOR TO BEGINNING ANY OF THEIR CONSTRUCTION.
 FAILURE TO NOTIFY BOTH CITY DEPARTMENTS IN ADVANCE OF BEGINNING CONSTRUCTION WILL RESULT IN THE ISSUANCE OF MONETARY FINES, AND REQUIRE REINSTALLATION OF ANY WATER OR SEWER FACILITIES NOT INSPECTED AS A RESULT OF THIS NOTIFICATION FAILURE.
 FAILURE TO CALL FOR INSPECTION, INSTALL A DOWNSTREAM PLUG, HAVE PERMITTED PLANS ON THE JOBSITE, OR ANY OTHER VIOLATION OF CITY OF RALEIGH STANDARDS WILL RESULT IN A FINE AND POSSIBLE EXCLUSION FROM FUTURE WORK IN THE CITY OF RALEIGH.


SITE PERMITTING APPROVAL
 Water and Sewer Permits (if Applicable)
 The City of Raleigh consents to the connection and extension of the City's Public Sewer System as shown on this plan. The material and construction methods used for this project shall conform to the standards and specifications of the City's Public Utilities Handbook. City of Raleigh Public Utilities Department Permit # **W-2108**
 The City of Raleigh consents to the connection and extension of the City's Public Water System as shown on this plan. The material and construction methods used for this project shall conform to the standards and specifications of the City's Public Utilities Handbook. City of Raleigh Public Utilities Department Permit # **W-4015**
CITY OF RALEIGH - PLANS AUTHORIZED FOR CONSTRUCTION
 Electronic Approval: This approval is being issued electronically. This approval is valid only upon the signature of a City of Raleigh Review Officer Below. The City will retain a copy of the approved plans. Any work authorized by this approval must proceed in accordance with the plans kept on file with the City. This electronic approval may not be edited once issued. Any modification to this approval once issued will invalidate this approval.
 City of Raleigh Development Approval
 Raleigh Water Review Officer

CLIENT:
 PRESERVE AT JONES DAIRY, LLC
 10534 ARNOLD PALMER DRIVE
 RALEIGH, NC 27617 919-491-0761

NO.	DATE	REVISIONS
1	2023-01-23	REVISED STORM IN REAR YARDS OF LOTS 200-207 TO FLOW TOWARDS FIGHTING BUILDING
2	2023-01-24	REVISED PHASE LINES
3	2023-01-28	REVISED STORM PIPE DATA FROM STORM STRUCTURES LOT TO LOT COMMENTS ON STORM DRAINAGE
4	2023-01-28	REVISED POND GRADING AND BEYOND PER TOWN REVIEW
5	2023-01-28	REVISED POND GRADING AND BEYOND PER TOWN REVIEW
6	2023-01-28	REVISED POND GRADING ON LOTS 111-112 AND 257-260
7	2023-01-29	UPDATED DAILY PROFILE FOR FRESHWATER DRAINAGE AND HEADWAY CONNECTION TO FRESHWATER DRAINAGE
8	2024-02-29	STORM AND SANITARY RELATED TO REVISION OUTLINE 10/25/24

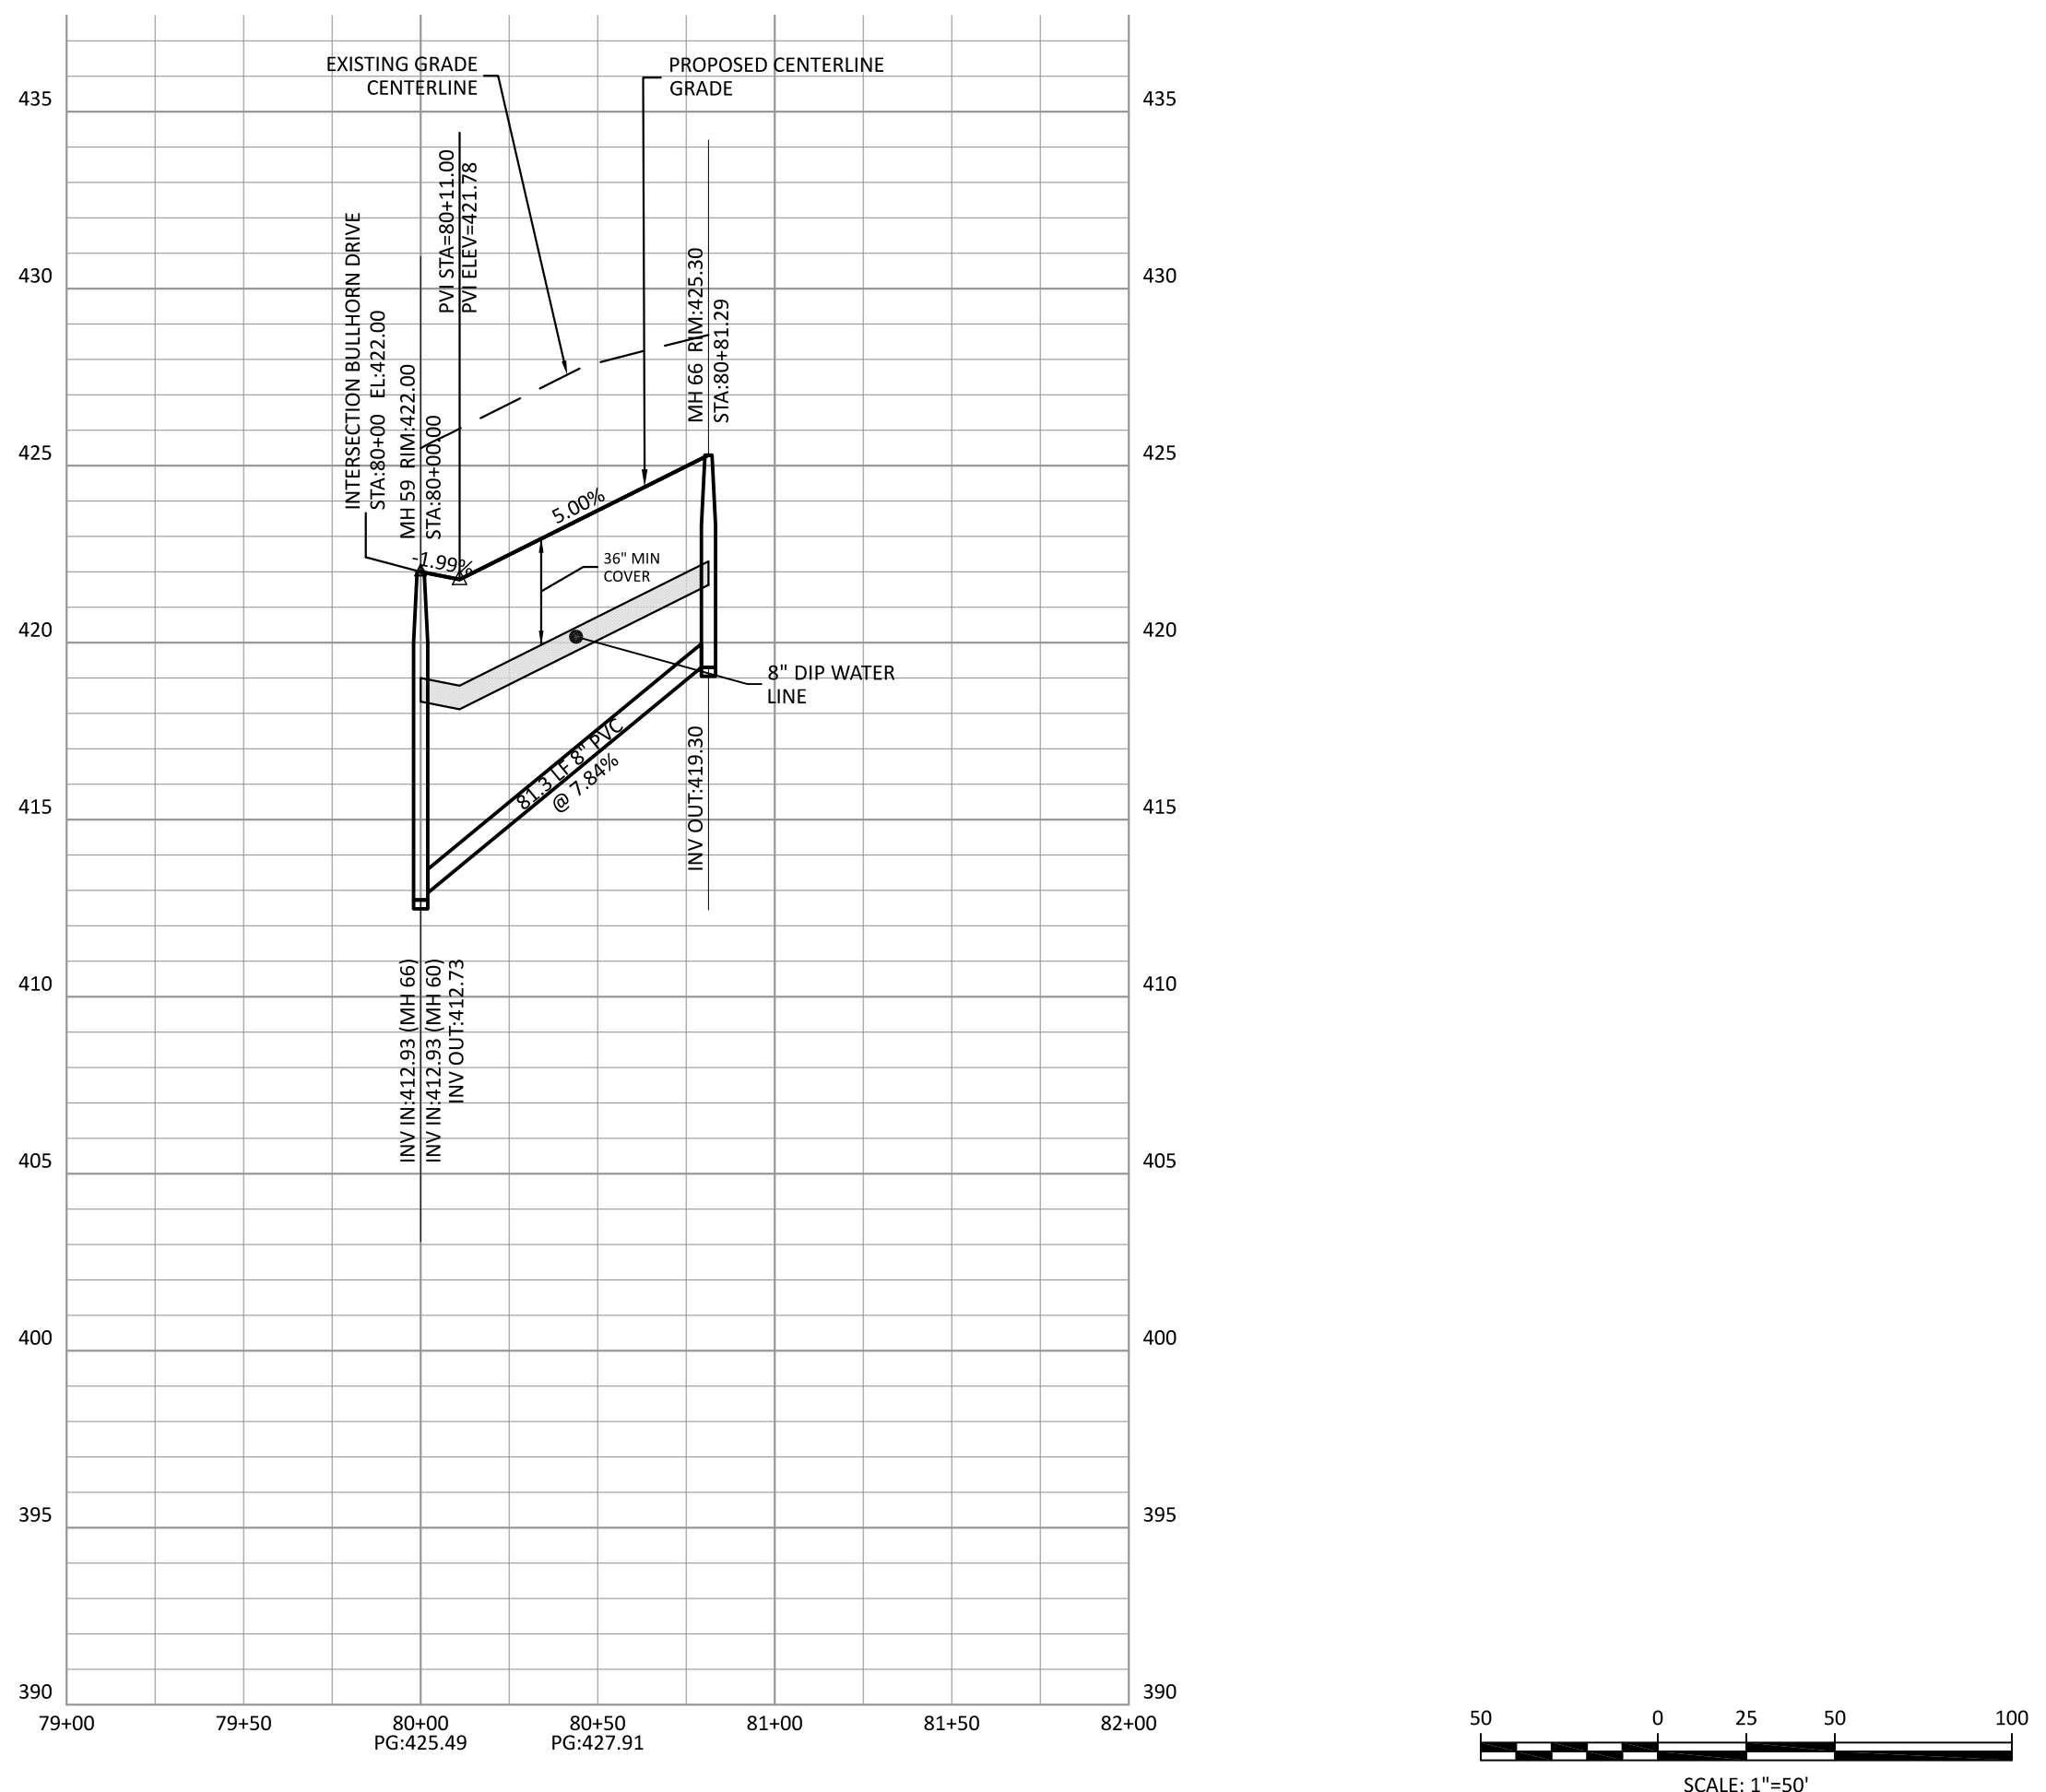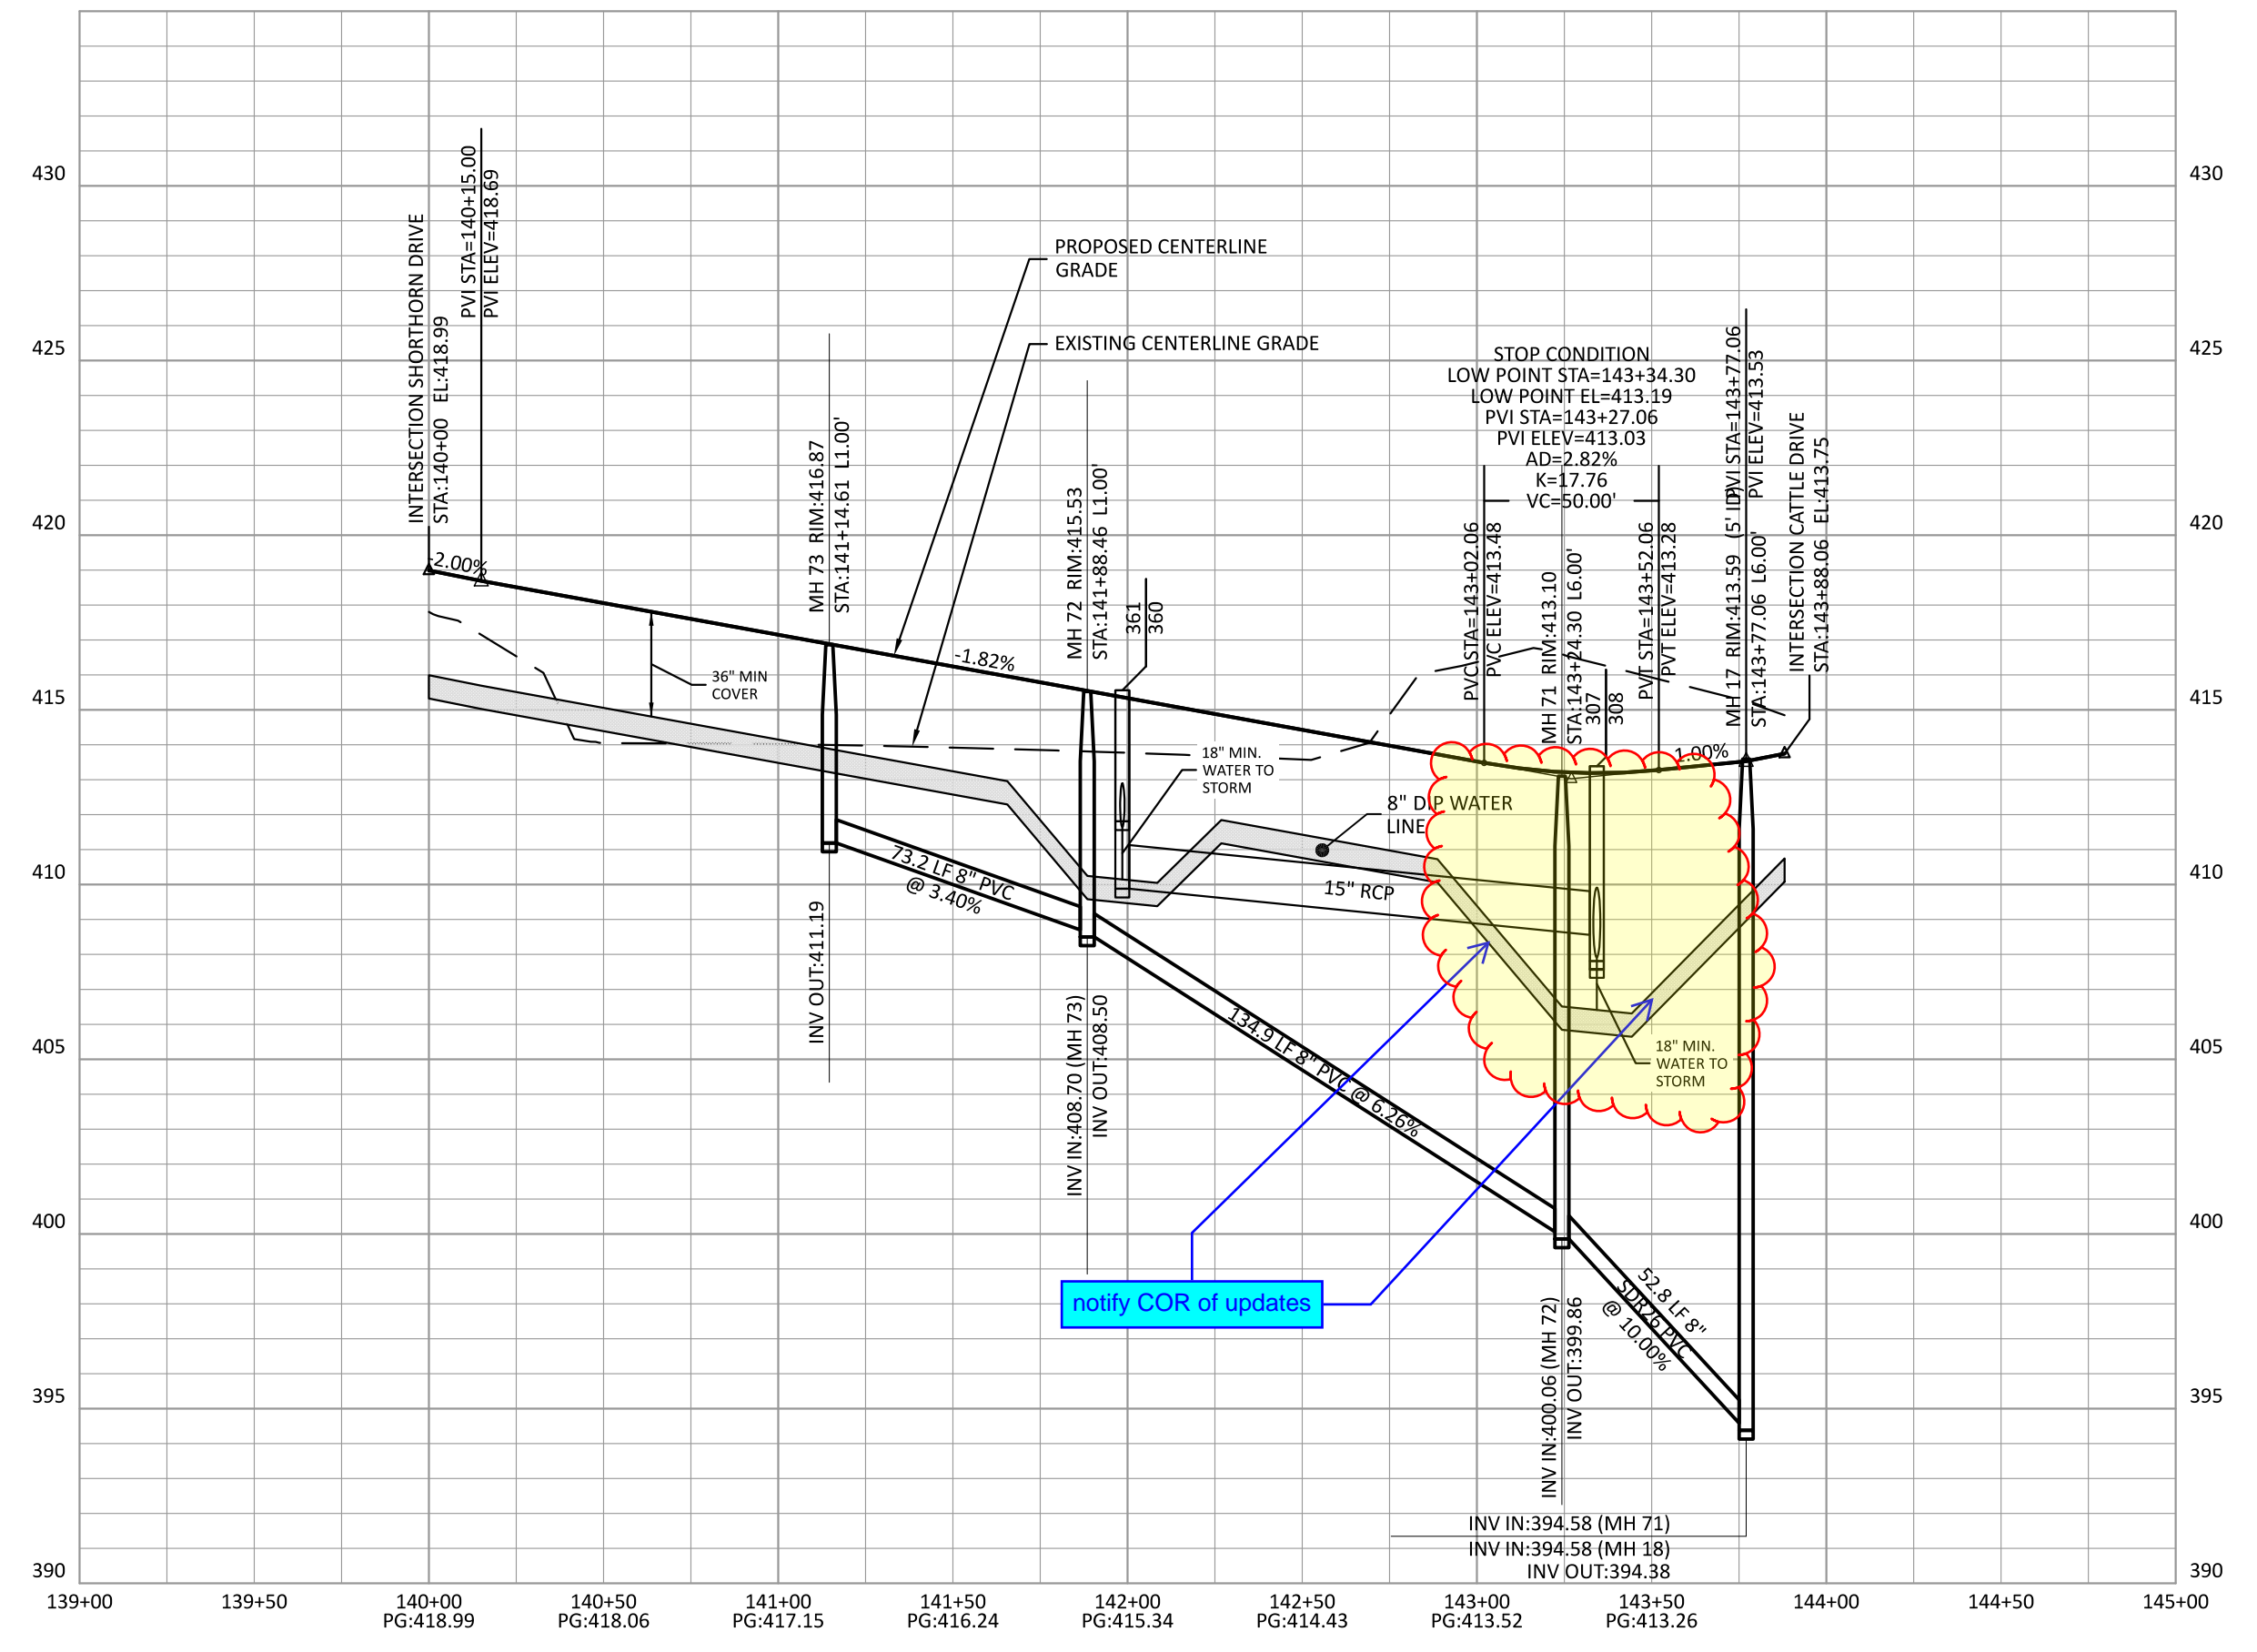

PRESERVE AT JONES DAIRY - CENTRAL CONSTRUCTION DRAWINGS
 COW BARN WAY & PANTANIERO WAY
 PLAN AND PROFILE

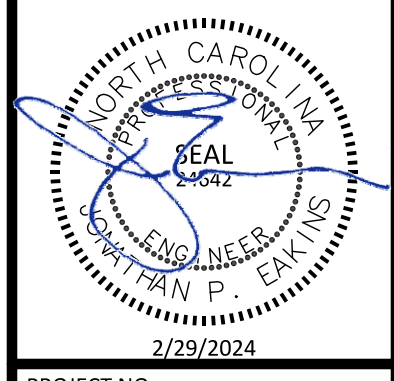

PROJECT NO: ...
 DESIGN BY: JPE
 DRAWN BY: RSF
 SCALE: 1"=50'
 DATE: 2023-01-27
 SHEET NO: **P9.1**

