



**ATTENTION CONTRACTORS**  
 THE CONSTRUCTION CONTRACTOR RESPONSIBLE FOR THE EXTENSION OF WATER, SEWER AND/OR REUSE, AS APPROVED IN THESE PLANS, IS RESPONSIBLE FOR CONTACTING THE PUBLIC UTILITIES DEPARTMENT AT 919-996-6540 AT LEAST 24 HOURS PRIOR TO BEGINNING ANY OF THEIR CONSTRUCTION.  
 FAILURE TO NOTIFY BOTH CITY DEPARTMENTS IN ADVANCE OF BEGINNING CONSTRUCTION WILL RESULT IN THE ISSUANCE OF MONETARY FINES, AND REQUIRE REINSTALLATION OF ANY WATER OR SEWER FACILITIES NOT INSPECTED AS A RESULT OF THIS NOTIFICATION FAILURE.  
 FAILURE TO CALL FOR INSPECTION, INSTALL A DOWNSTREAM PLUG, HAVE PERMITTED PLANS ON THE JOBSITE, OR ANY OTHER VIOLATION OF CITY OF RALEIGH STANDARDS WILL RESULT IN A FINE AND POSSIBLE EXCLUSION FROM FUTURE WORK IN THE CITY OF RALEIGH.

**SITE PERMITTING APPROVAL**  
 Water and Sewer Permits (if Applicable)  
 The City of Raleigh consents to the connection and extension of the City's Public Sewer System as shown on this plan. The material and construction methods used for this project shall conform to the standards and specifications of the City's Public Utilities Handbook. City of Raleigh Public Utilities Department Permit # **2023-08-01**.  
 The City of Raleigh consents to the connection and extension of the City's Public Water System as shown on this plan. The material and construction methods used for this project shall conform to the standards and specifications of the City's Public Utilities Handbook. City of Raleigh Public Utilities Department Permit # **2023-08-01**.  
**CITY OF RALEIGH - PLANS AUTHORIZED FOR CONSTRUCTION**  
 Electronic Approval: This approval is being issued electronically. This approval is valid only upon the signature of a City of Raleigh Review Officer Below. The City will retain a copy of the approved plans. Any work authorized by this approval must proceed in accordance with the plans kept on file with the City. This electronic approval may not be edited once issued. Any modification to this approval once issued will invalidate this approval.  
 City of Raleigh Development Approval  
 Raleigh Water Review Officer


**The Nau Company**  
 Consulting Civil Engineers  
 PO Box 810, Rolesville, NC 27571  
 919-435-6395  
 NCBELS License P-0751

CLIENT:  
 PRESERVE AT JONES DAIRY, LLC  
 10534 ARNOLD PALMER DRIVE  
 RALEIGH, NC 27617 919-491-0761

NO.	DATE	REVISIONS
1	2023-03-23	REVISED STORM IN REAR YARDS OF LOTS 200-207 TO FLOW TOWARDS FIGHTING BUILDING
2	2023-03-24	REVISED PHASE LINES
3	2023-03-28	REVISED STORM PIPE DATA FROM STORM STRUCTURES LOT TO LOT COMMENTS ON STORM DRAINAGE
4	2023-06-05	REVISED STORM PIPE DATA FROM STORM STRUCTURES LOT TO LOT COMMENTS ON STORM DRAINAGE
5	2023-06-05	REVISED POND GRADING AND BELEGONS PER TOWN REVIEW
6	2023-08-01	REVISED POND GRADING ON LOTS 111-112 AND 217-260
7	2024-03-19	UPDATED DAILY PROFILE FOR FREESTALL DRIVE AND HERD WAY CONNECTION TO FREESTALL DRIVE
8	2024-02-29	10% STORM AND SANITARY RELATED TO REVISED OUTFALL

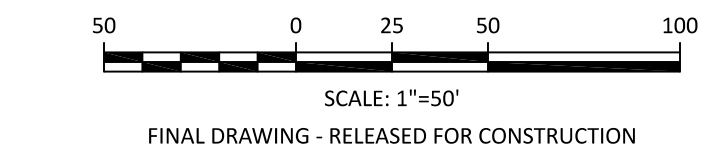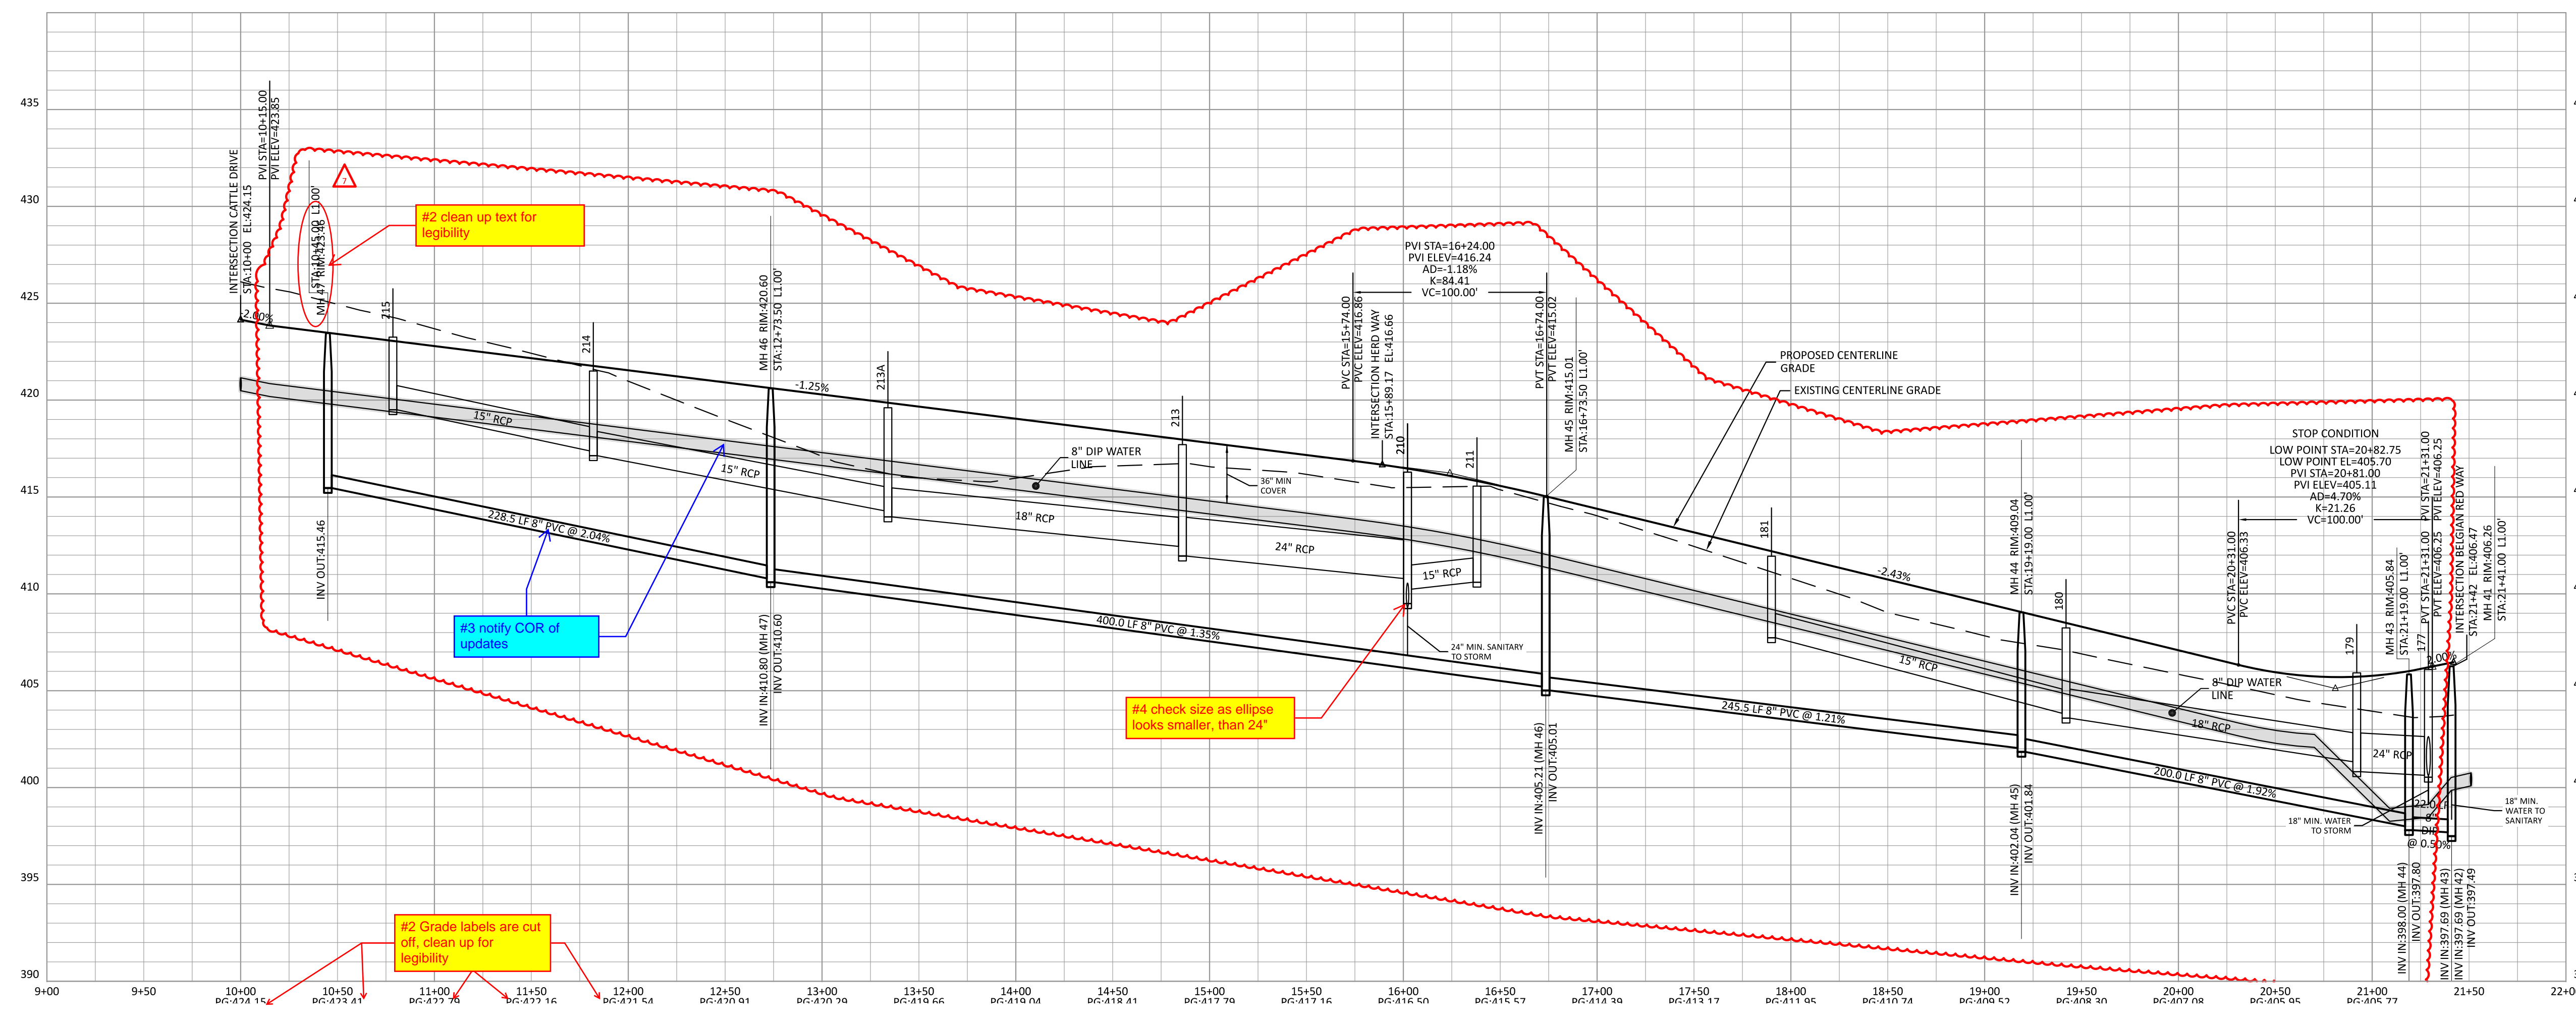

**PRESERVE AT JONES DAIRY - CENTRAL CONSTRUCTION DRAWINGS**  
 ROLESVILLE, NC  
 FREESTALL DRIVE PLAN AND PROFILE

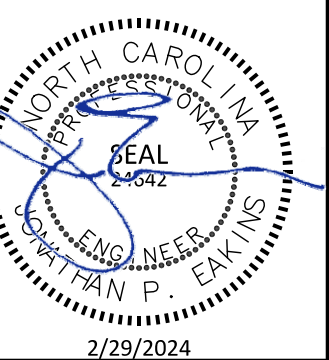

PROJECT NO: ...

DESIGN BY: JPE

DRAWN BY: RSF

SCALE: 1"=50'

DATE: 2023-01-27

SHEET NO: **P11.1**

#2 clean up text for legibility

#3 notify COR of updates

#4 check size as ellipse looks smaller, than 24"

#2 Grade labels are cut off, clean up for legibility