

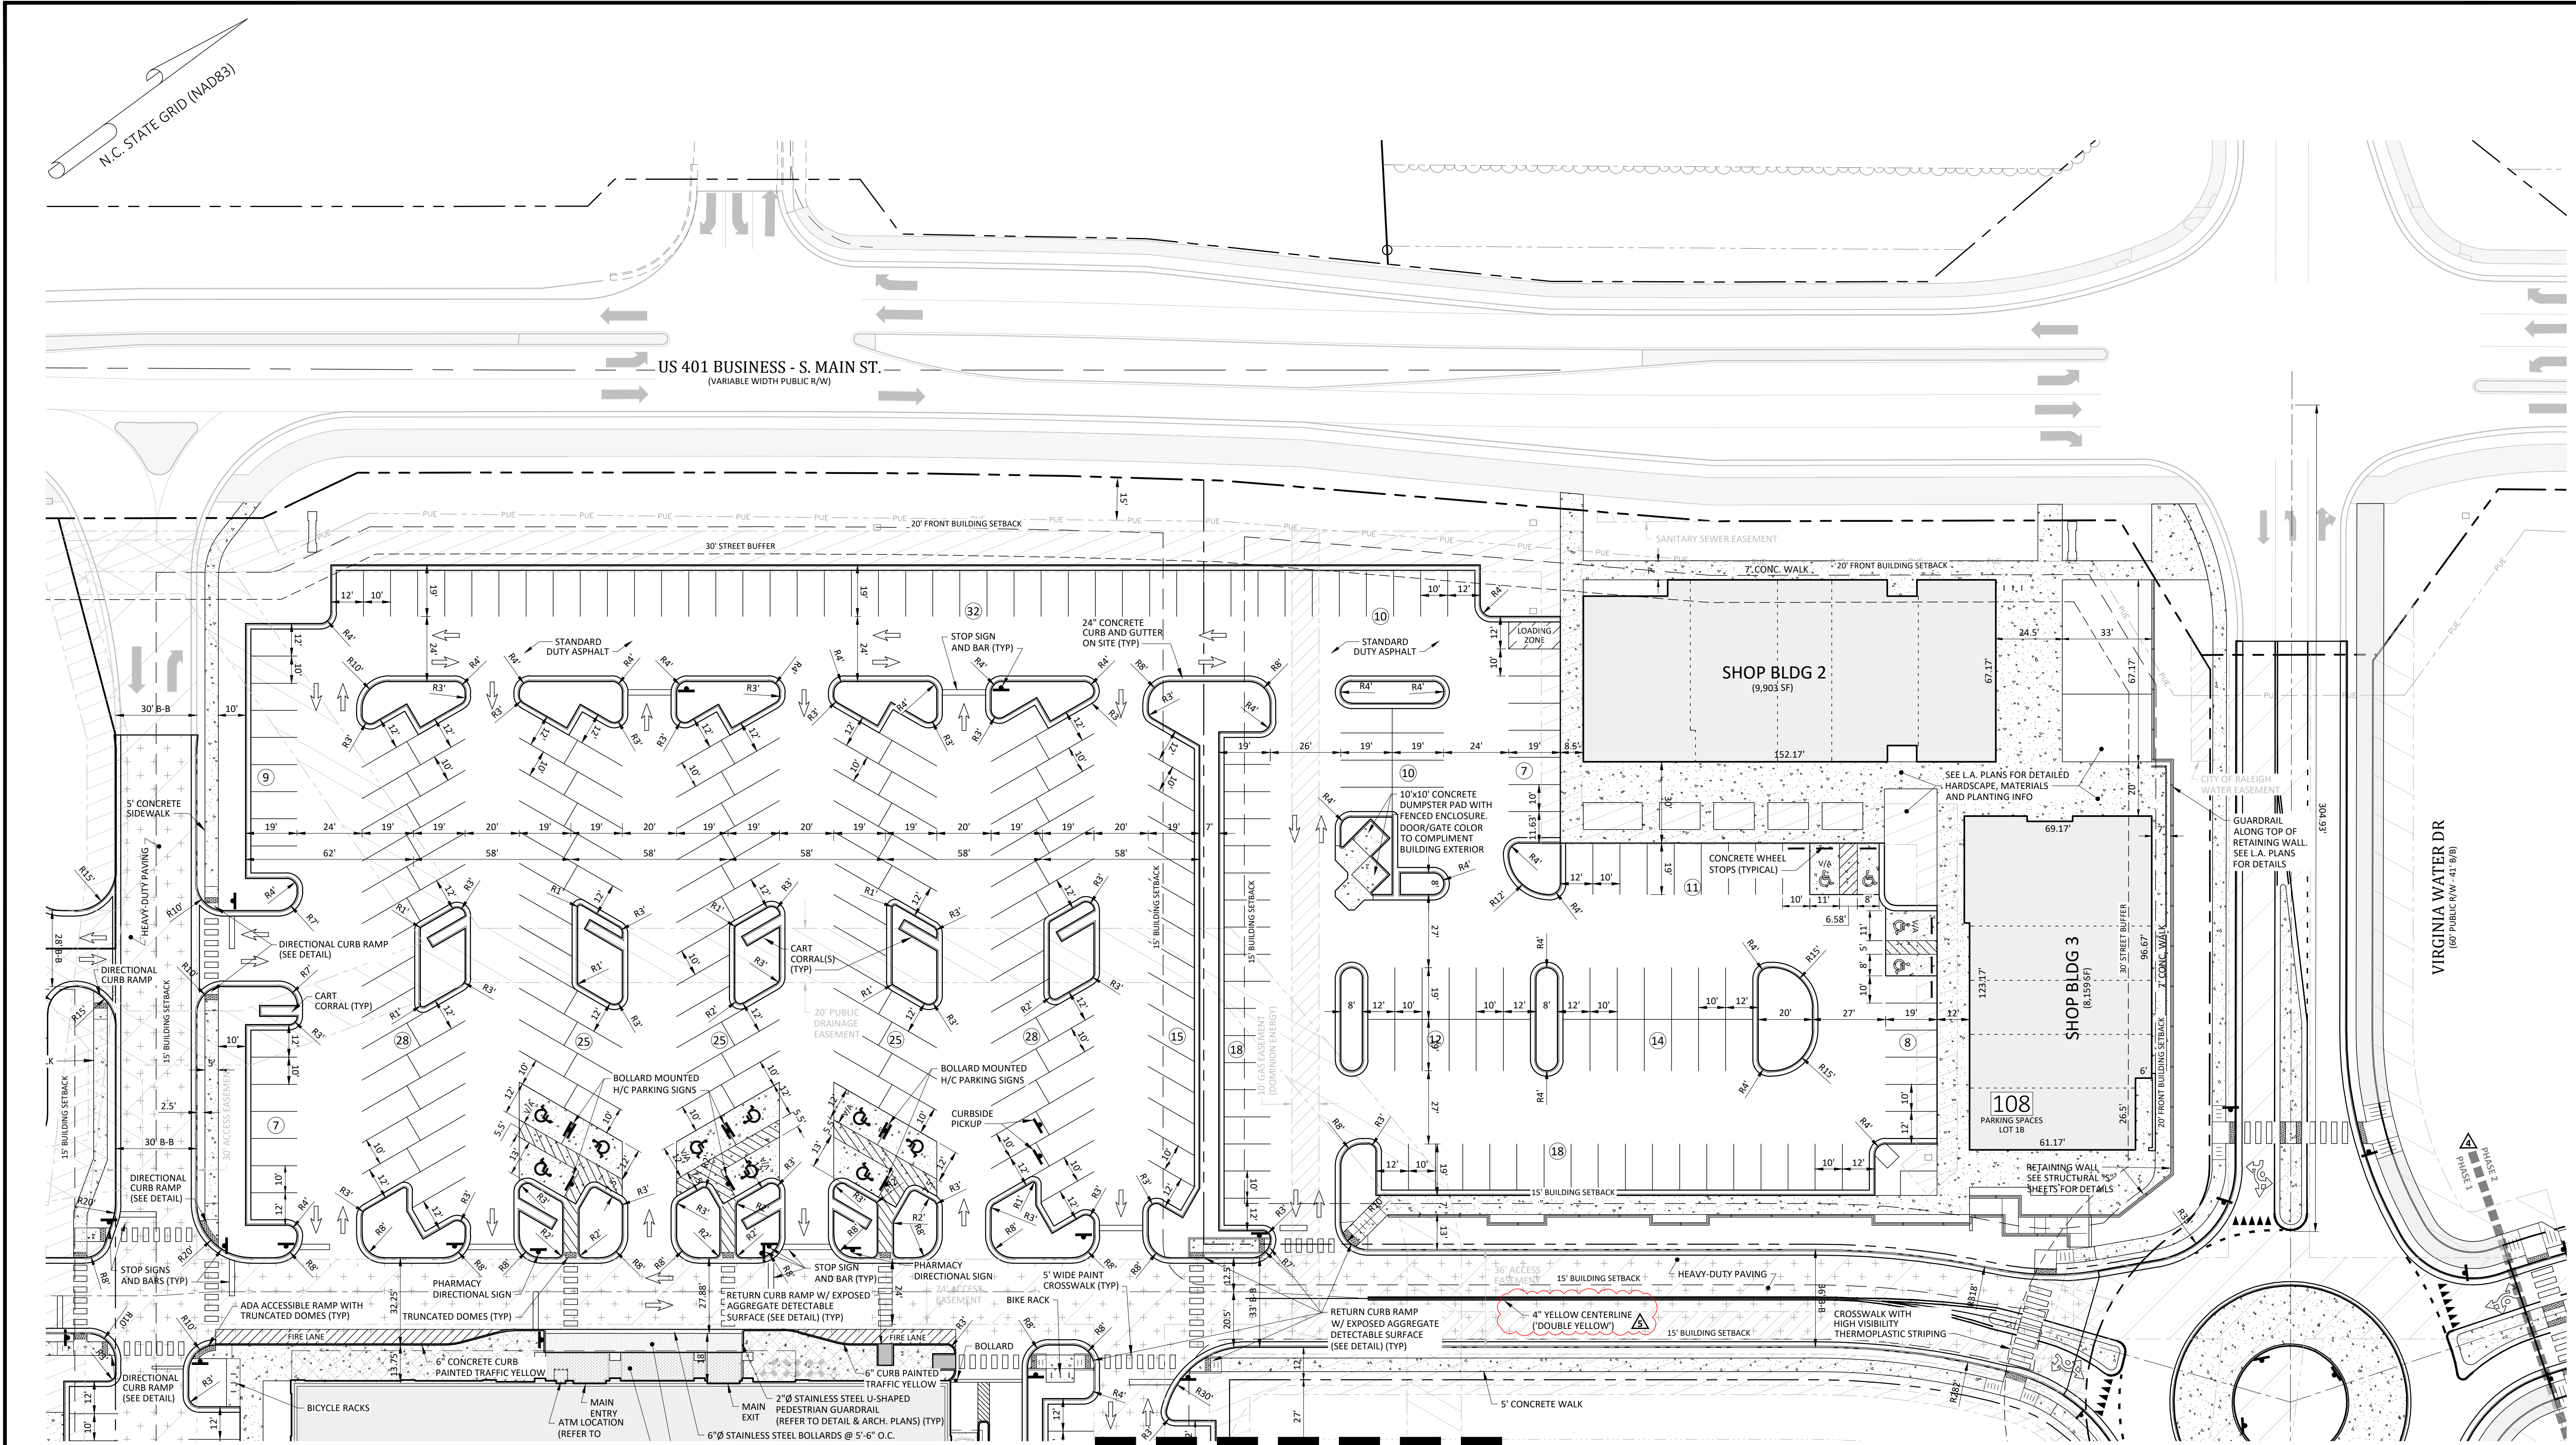


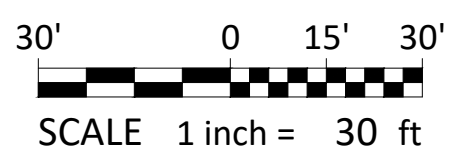

REFERENCE LINE - SEE SHEET C2.20

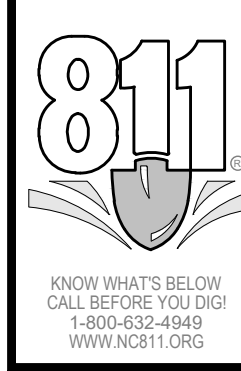

REVISIONS:

#	DATE	DESCRIPTION
1	26-OCT-23	SDP 23-05 / CID 23-01 COMBINED REVIEW
2	14-NOV-23	ISSUED FOR CONSTRUCTION
3	20-MAR-24	REVISED PER OWNER/FENANT COMMENTS
4	11-JUL-24	ADDED PLANS & CUE BULLETIN (CID 23-01 REVISIONS)
5	4-SEP-24	REVISED PER OWNER/FENANT COMMENTS

CROSLAND
SOUTHEAST

SITE PLAN 'A'

PUBLIX AT WALLBROOK AND
WALLBROOK ROADWAY IMPROVEMENTS

Town of Rolesville Project No. SDP 23-05 & CID 23-01

S Main St. / US 401 and Virginia Water Drive

Rolesville, Wake County, North Carolina

NC License: P-1199
ARK
CONSULTING
GROUP PLLC
ENGINEERS & PLANNERS
935-A Conference Dr.
Raleigh, NC 27603
(919) 558-0888
www.arkconsultinggroup.com

9/4/2024

SEAL

31970

ENGINEER

DAVID M. C. FABUNDI

Project Manager: BCF

Drawn By: DLC

Checked By: STA


Project Number: 21089 / 22012

Drawing Number: D-1219-CD








Date: October 26, 2023

C2.10

SDP

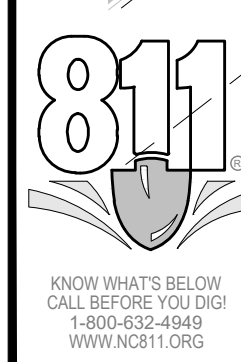

Project Manager:	BCF
Drawn By:	DLC
Checked By:	STA
Project Number:	21089 / 22012
Drawing Number:	D-1219-CD
Date:	October 26, 2023
C2.20	
SDP	

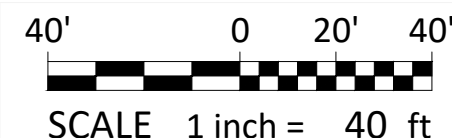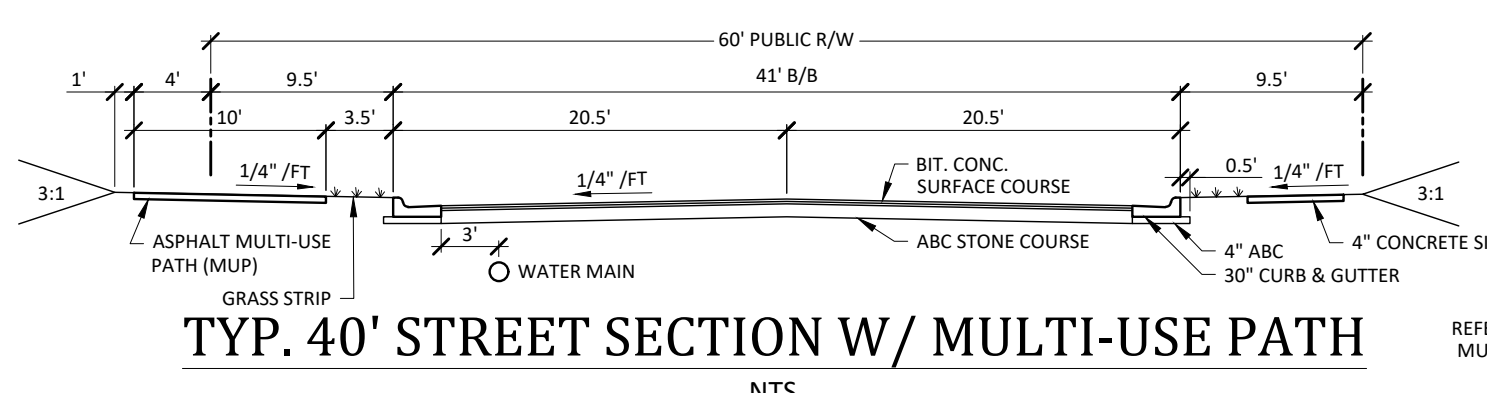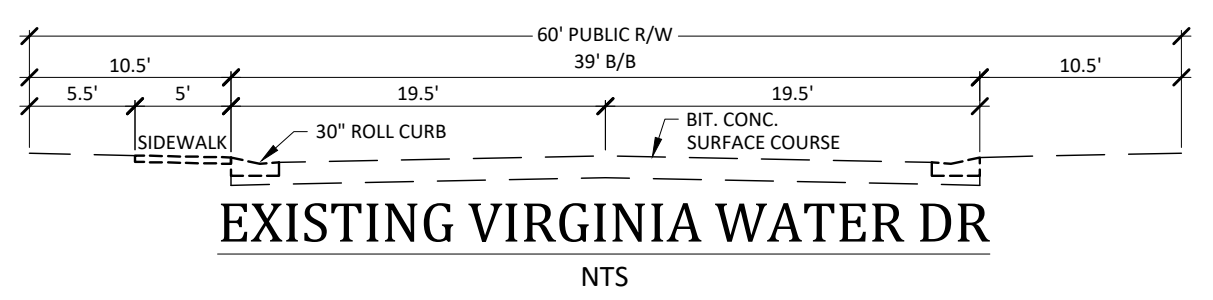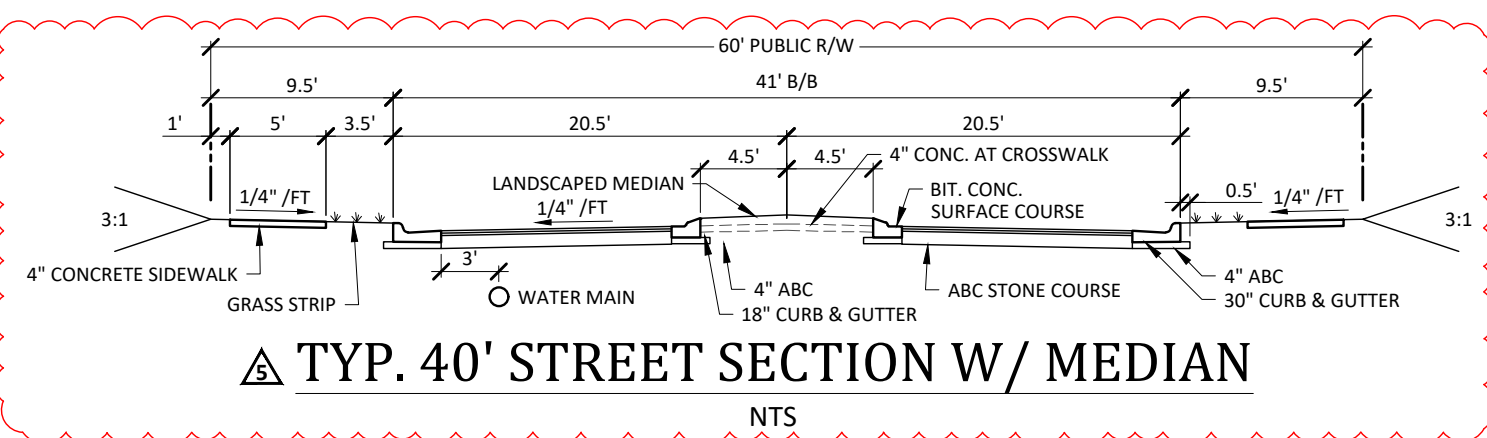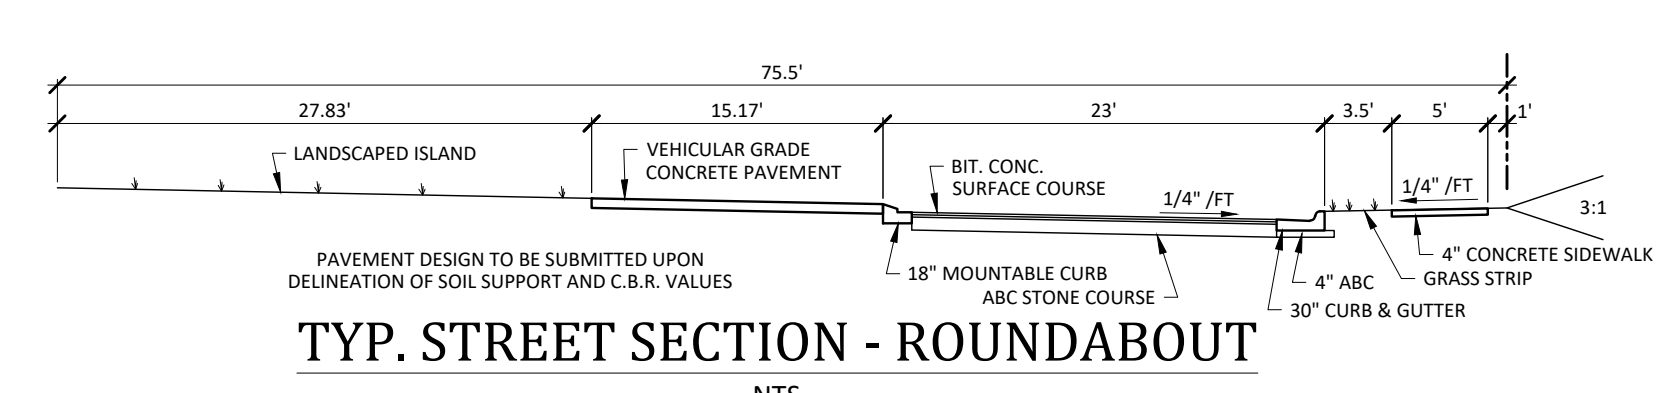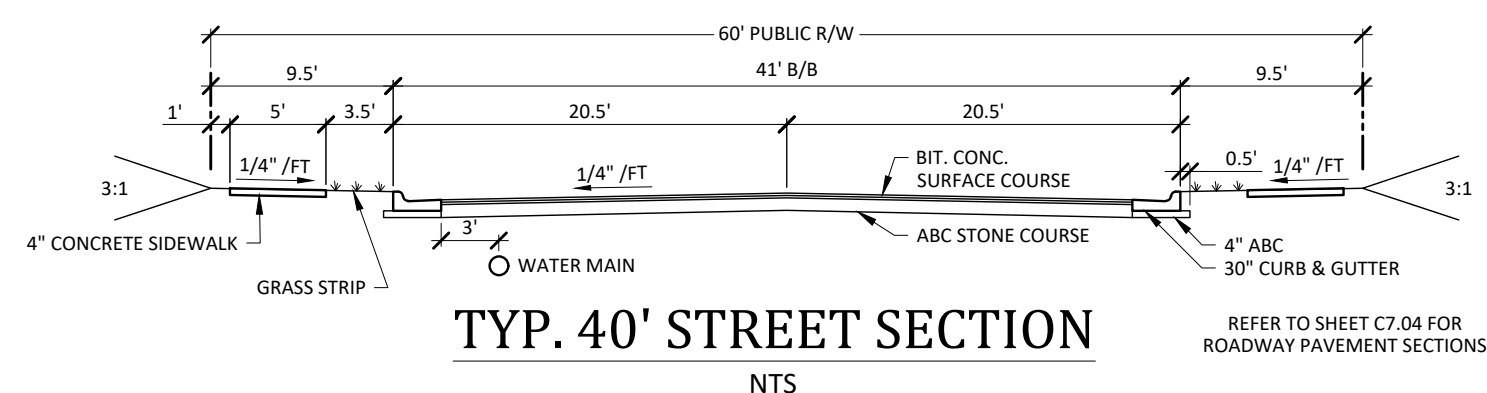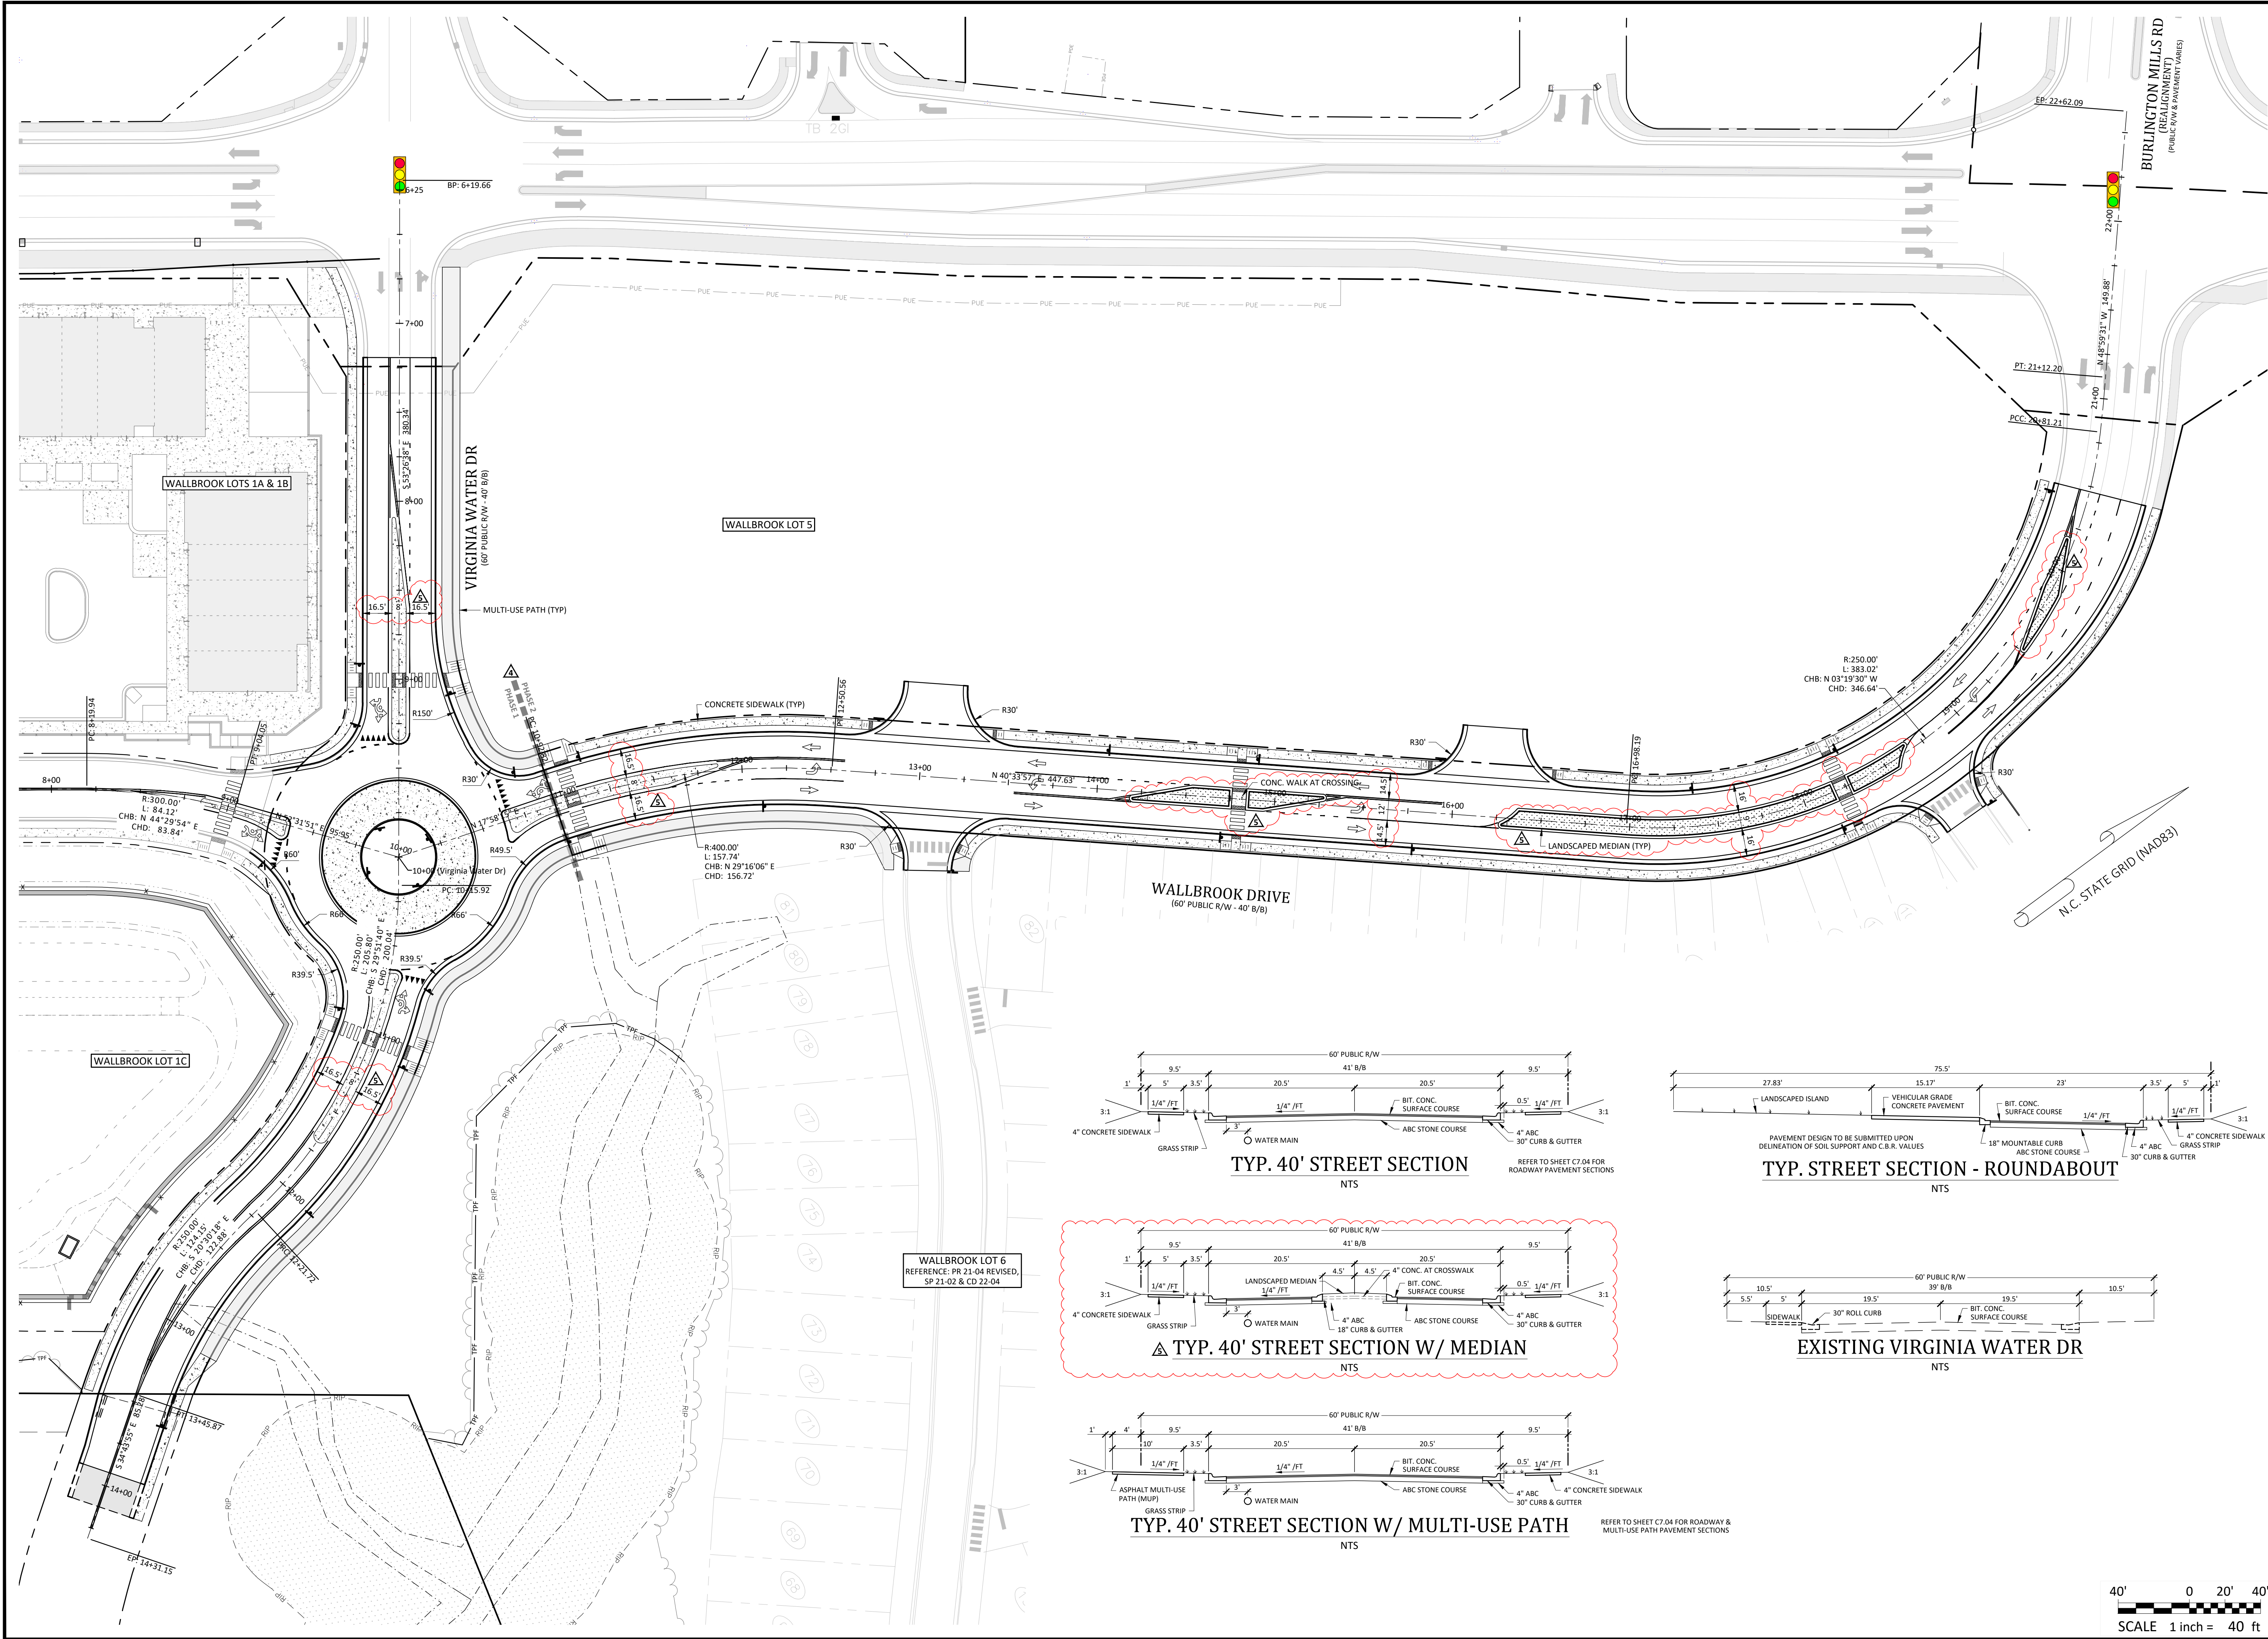

REVISIONS:

#	DATE	DESCRIPTION
1	26-OCT-23	SDP 23-05 / CID 23-01 COMBINED REVIEW
2	14-NOV-23	ISSUED FOR CONSTRUCTION
3	20-MAR-24	REVISED PER OWNER/FENANT COMMENTS
4	11-JUL-24	ADDED MANHOLE & CUL BULLETIN (CID 23-01)
5	4-SEP-24	REVISED PER OWNER/FENANT COMMENTS

CROSLAND
SOUTHEAST

ROADWAY - LAYOUT PLAN

**PUBLIX AT WALLBROOK AND
WALLBROOK ROADWAY IMPROVEMENTS**
Town of Rolesville Project No. SDP 23-05 & CID 23-01
S Main St. / US 401 and Virginia Water Drive
Rolesville, Wake County, North Carolina


NC License: P-1159
ARK CONSULTING GROUP PLLC
ENGINEERS & PLANNERS
935-A Conference Dr.
Cary, NC 27513
(919) 558-0888
www.arkconsultinggroup.com

SEAL
31970
NORTH CAROLINA
REGISTERED PROFESSIONAL
ENGINEER
DAVID M. C. FABUNDI
9/4/2024


Project Manager: BCF
Drawn By: DLC
Checked By: STA
Project Number: 21089 / 22012
Drawing Number: D-1219-CD
Date: October 26, 2023

C2.40
CID

© 2024 CROSLAND SOUTHEAST - PROJECTS IN THE CROSLAND SOUTHEAST - WALLBROOK ROADWAY IMPROVEMENTS - WALLBROOK SHOP DRAWING - 2.40, See Dimensions, Notes, & Details on Drawings. Scale: 1/4" = 10' 11/32"

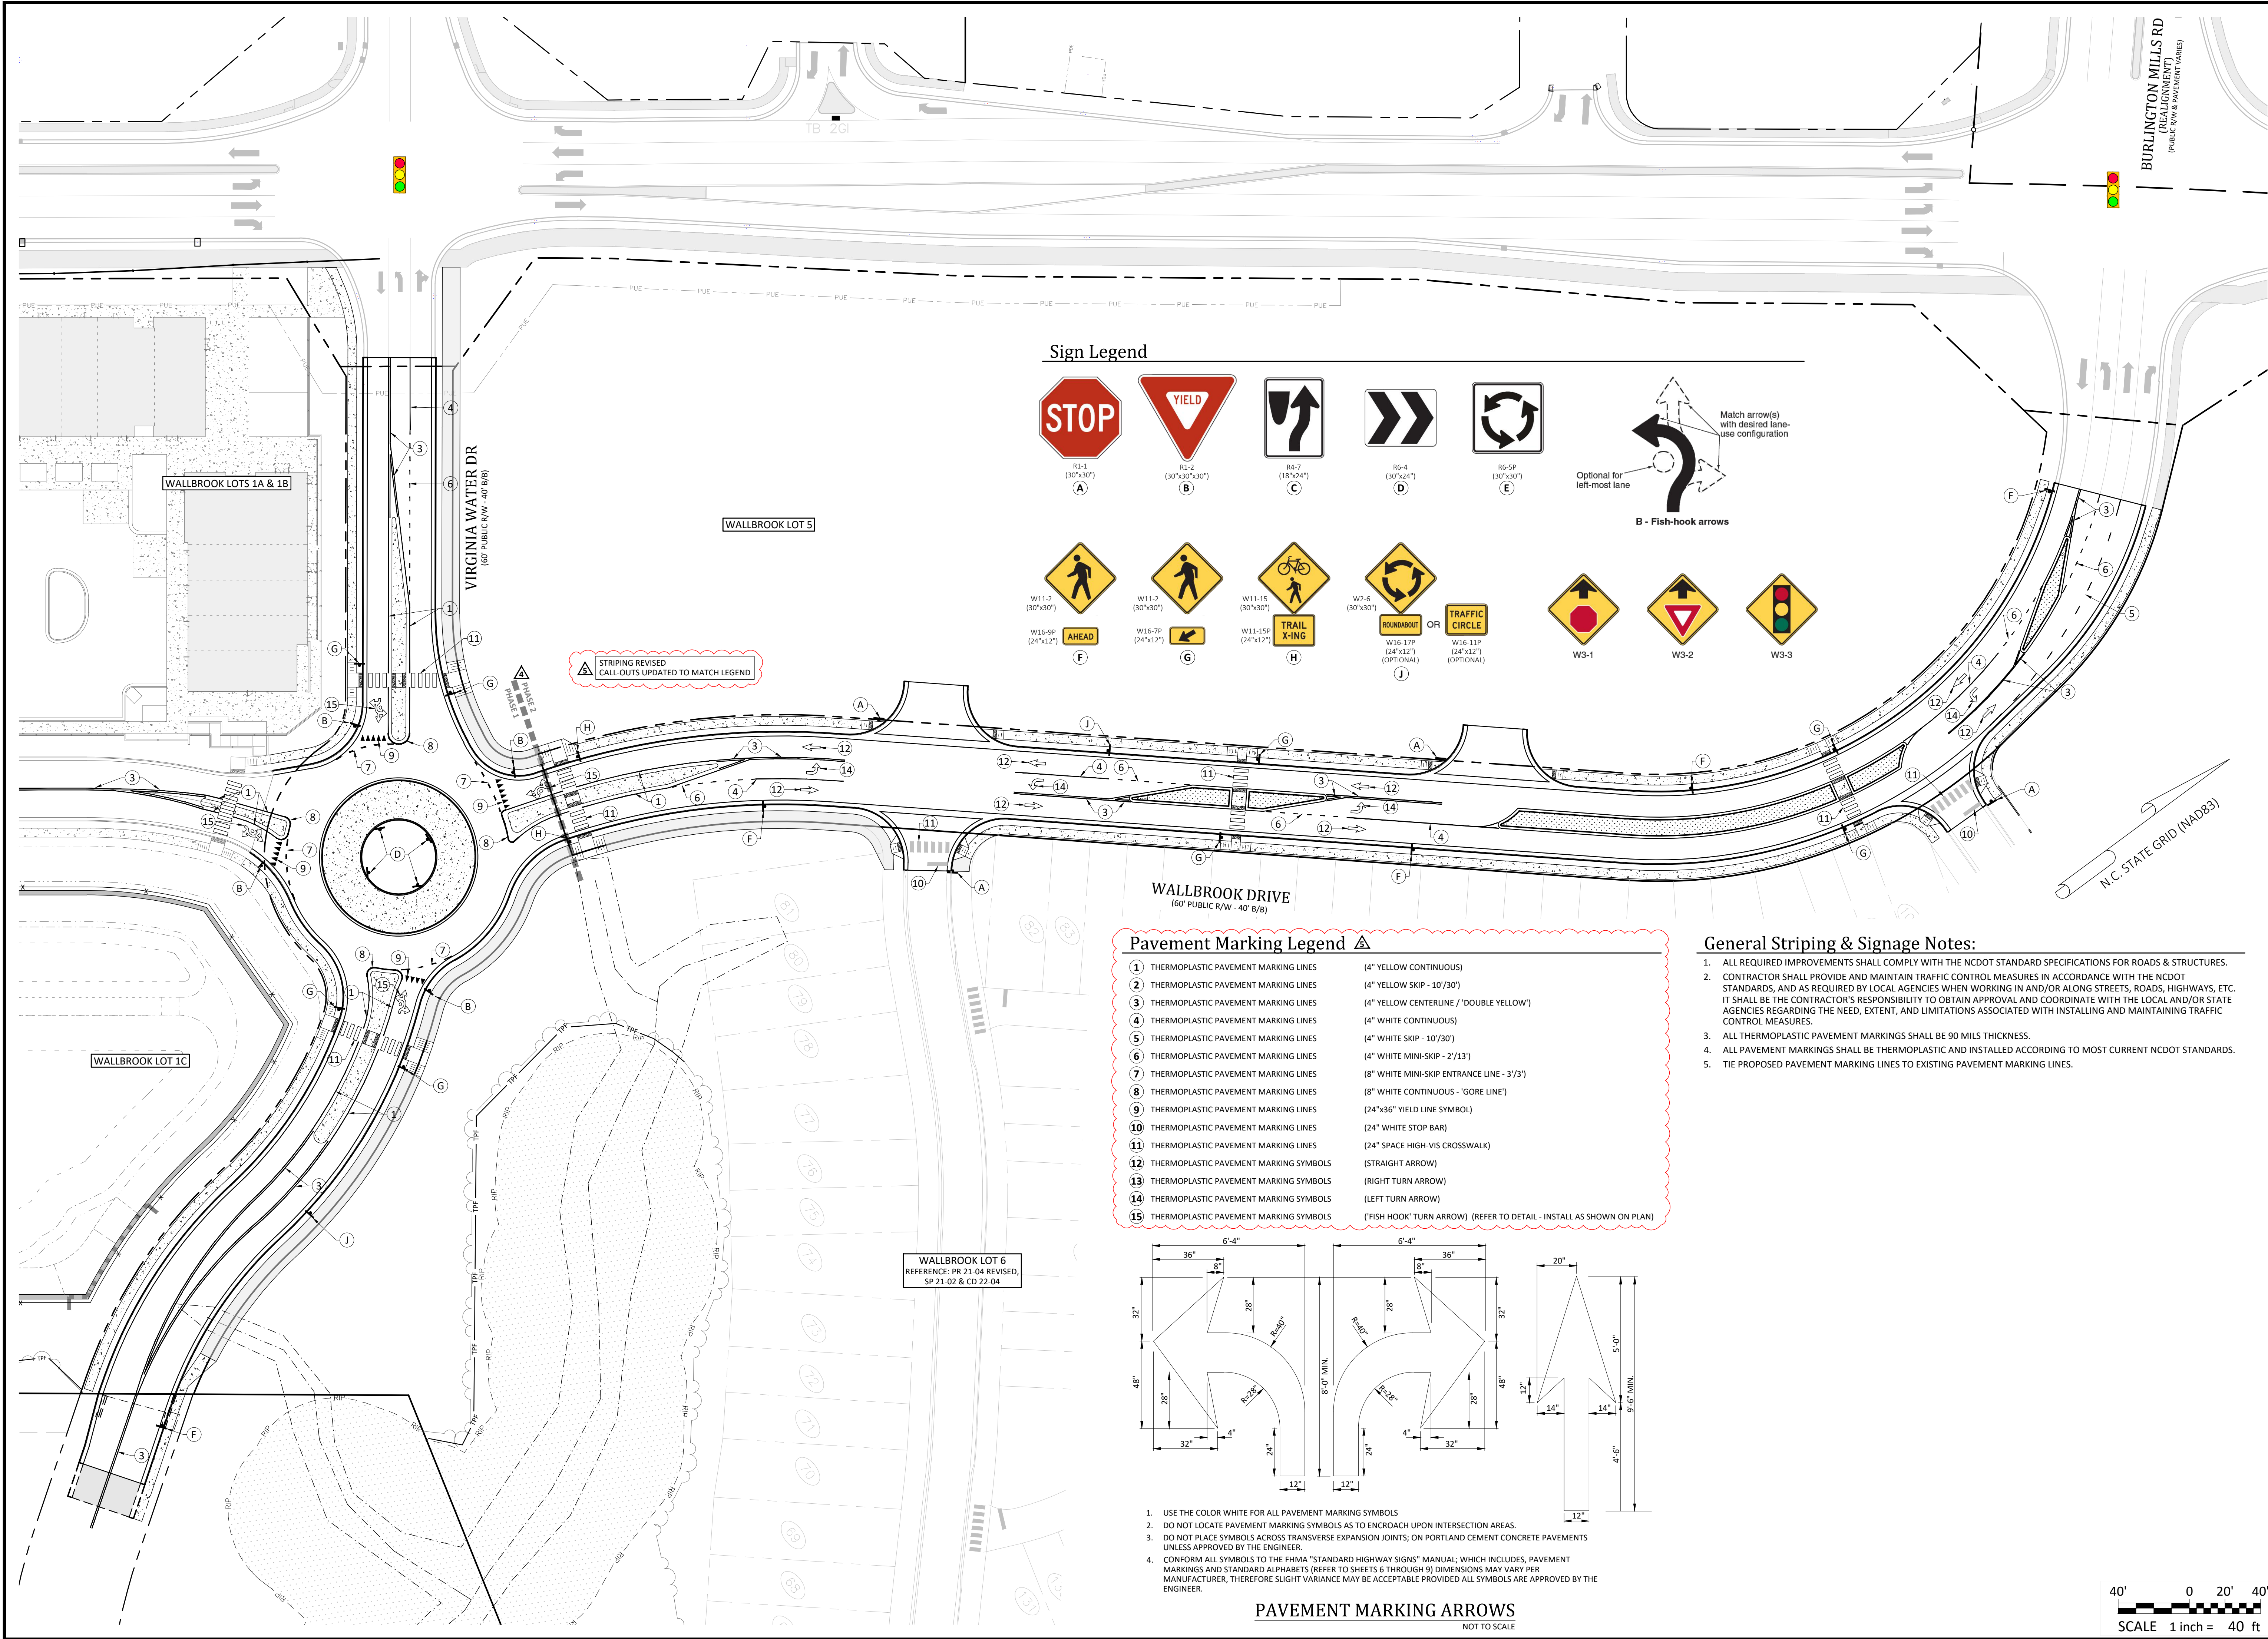


Sign Legend

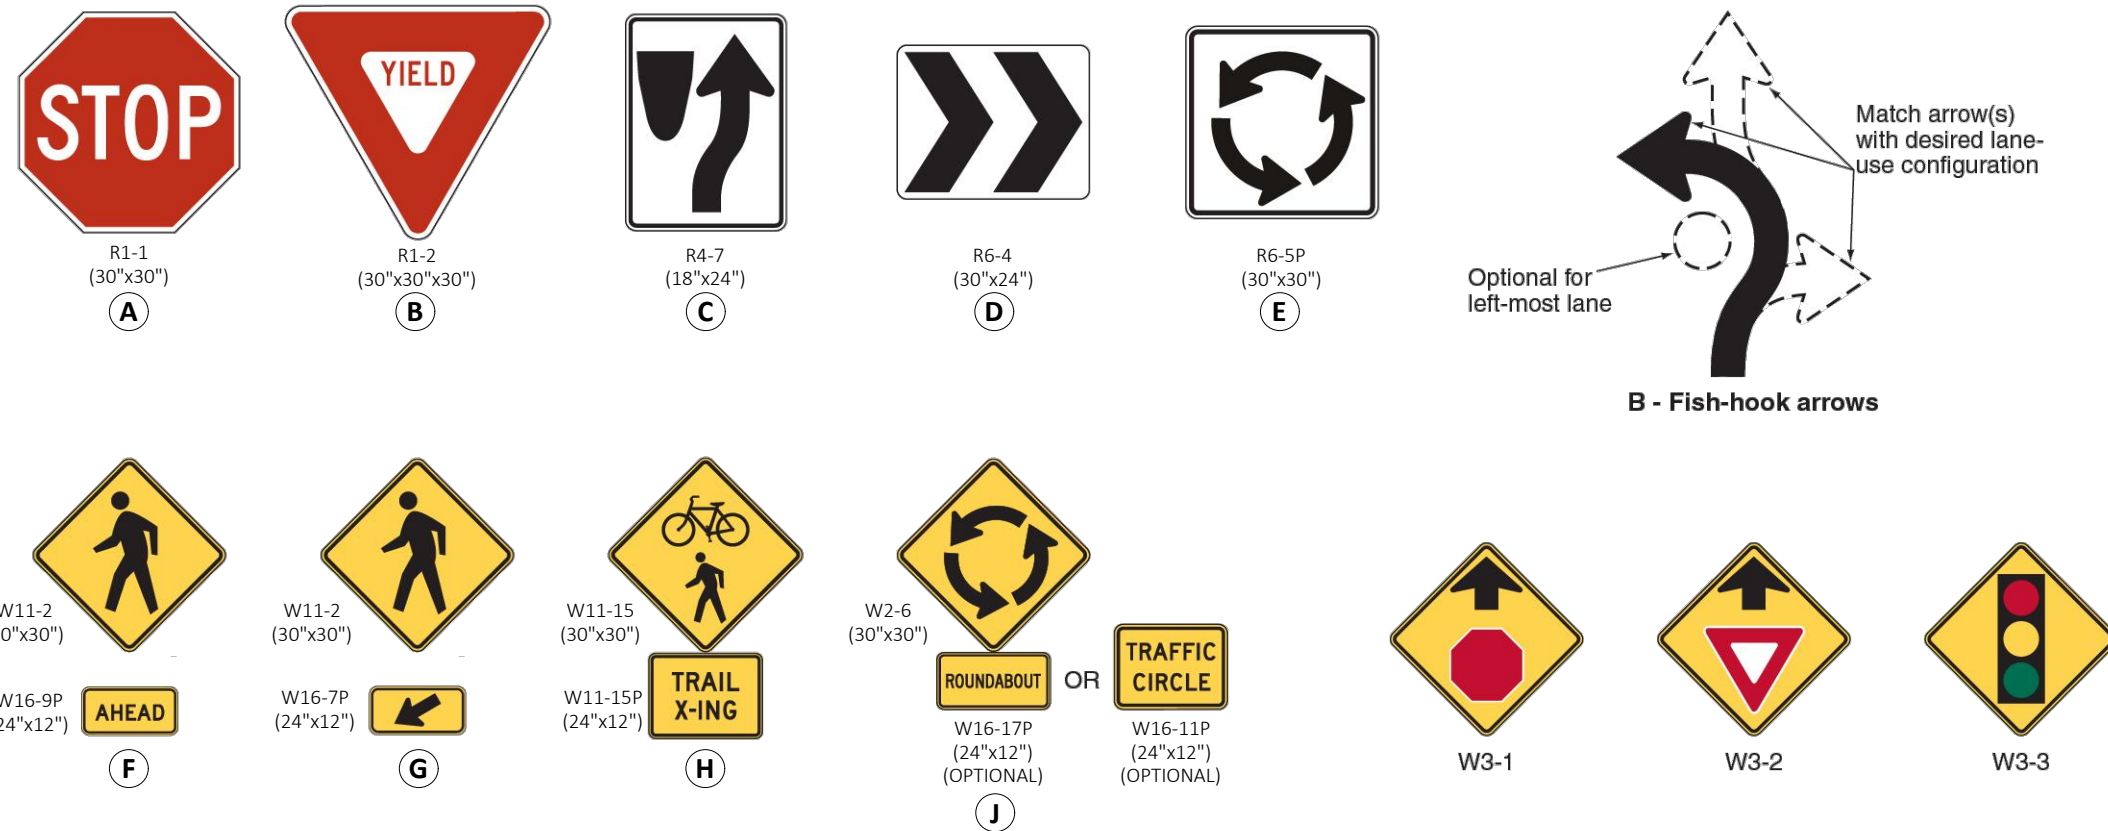

Pavement Marking Legend

- | | | |
|----|--|---|
| 1 | THERMOPLASTIC PAVEMENT MARKING LINES | (4" YELLOW CONTINUOUS) |
| 2 | THERMOPLASTIC PAVEMENT MARKING LINES | (4" YELLOW SKIP - 10'/30') |
| 3 | THERMOPLASTIC PAVEMENT MARKING LINES | (4" YELLOW CENTERLINE / "DOUBLE YELLOW") |
| 4 | THERMOPLASTIC PAVEMENT MARKING LINES | (4" WHITE CONTINUOUS) |
| 5 | THERMOPLASTIC PAVEMENT MARKING LINES | (4" WHITE SKIP - 10'/30') |
| 6 | THERMOPLASTIC PAVEMENT MARKING LINES | (4" WHITE MINI-SKIP - 2'/13') |
| 7 | THERMOPLASTIC PAVEMENT MARKING LINES | (8" WHITE MINI-SKIP ENTRANCE LINE - 3'/3') |
| 8 | THERMOPLASTIC PAVEMENT MARKING LINES | (8" WHITE CONTINUOUS - "GORE LINE") |
| 9 | THERMOPLASTIC PAVEMENT MARKING LINES | (24"x36" YIELD LINE SYMBOL) |
| 10 | THERMOPLASTIC PAVEMENT MARKING LINES | (24" WHITE STOP BAR) |
| 11 | THERMOPLASTIC PAVEMENT MARKING LINES | (24" SPACE HIGH-VIS CROSSWALK) |
| 12 | THERMOPLASTIC PAVEMENT MARKING SYMBOLS | (STRAIGHT ARROW) |
| 13 | THERMOPLASTIC PAVEMENT MARKING SYMBOLS | (RIGHT TURN ARROW) |
| 14 | THERMOPLASTIC PAVEMENT MARKING SYMBOLS | (LEFT TURN ARROW) |
| 15 | THERMOPLASTIC PAVEMENT MARKING SYMBOLS | ("FISH HOOK" TURN ARROW) (REFER TO DETAIL - INSTALL AS SHOWN ON PLAN) |

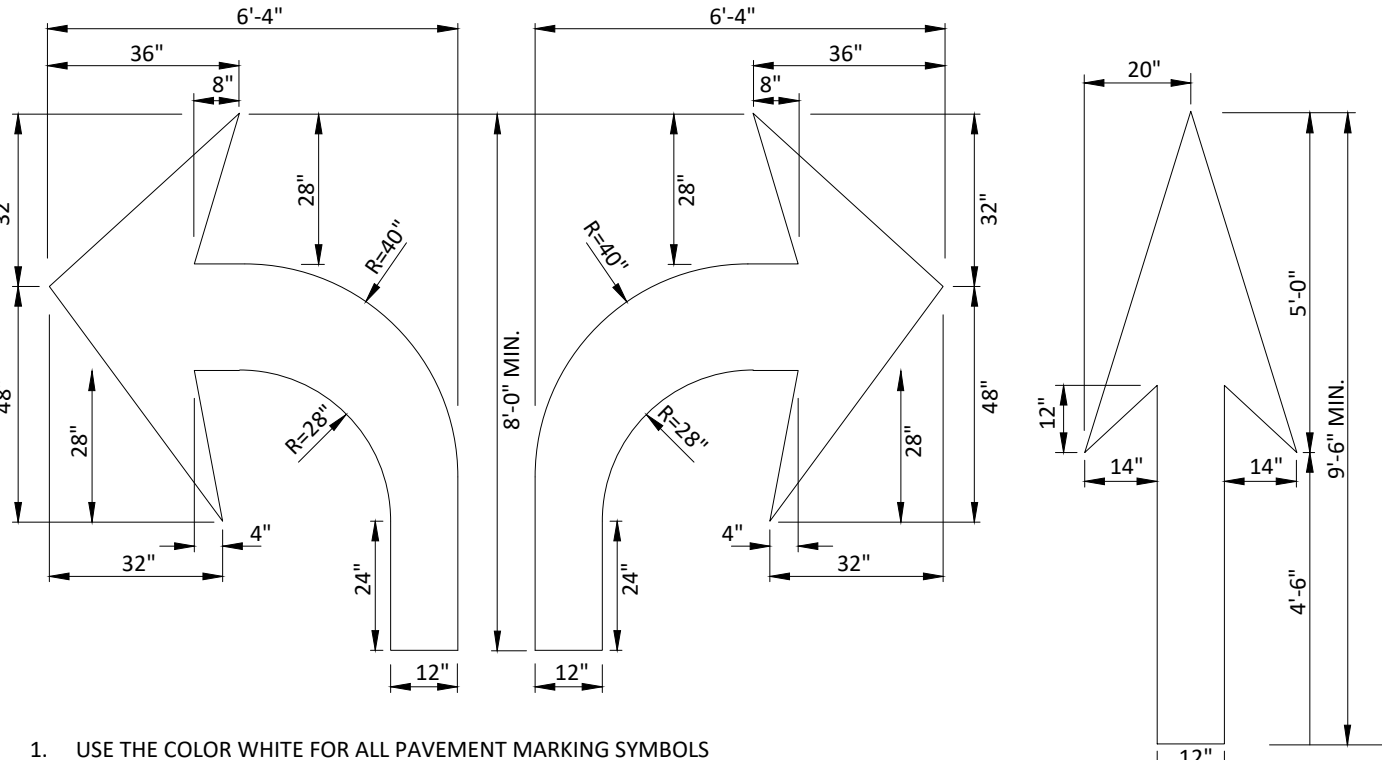

- USE THE COLOR WHITE FOR ALL PAVEMENT MARKING SYMBOLS
- DO NOT LOCATE PAVEMENT MARKING SYMBOLS AS TO ENCR OACH UPON INTERSECTION AREAS.
- DO NOT PLACE SYMBOLS ACROSS TRANSVERSE EXPANSION JOINTS, ON PORTLAND CEMENT CONCRETE PAVEMENTS UNLESS APPROVED BY THE ENGINEER.
- CONFORM ALL SYMBOLS TO THE FHWA "STANDARD HIGHWAY SIGNS" MANUAL, WHICH INCLUDES, PAVEMENT MARKINGS AND STANDARD ALPHABETS (REFER TO SHEETS 6 THROUGH 9) DIMENSIONS MAY VARY PER MANUFACTURER, THEREFORE SLIGHT VARIANCE MAY BE ACCEPTABLE PROVIDED ALL SYMBOLS ARE APPROVED BY THE ENGINEER.

General Striping & Signage Notes:

- ALL REQUIRED IMPROVEMENTS SHALL COMPLY WITH THE NCDOT STANDARD SPECIFICATIONS FOR ROADS & STRUCTURES.
- CONTRACTOR SHALL PROVIDE AND MAINTAIN TRAFFIC CONTROL MEASURES IN ACCORDANCE WITH THE NCDOT STANDARDS, AND AS REQUIRED BY LOCAL AGENCIES WHEN WORKING IN AND/OR ALONG STREETS, ROADS, HIGHWAYS, ETC. IT SHALL BE THE CONTRACTOR'S RESPONSIBILITY TO OBTAIN APPROVAL AND COORDINATE WITH THE LOCAL AND/OR STATE AGENCIES REGARDING THE NEED, EXTENT, AND LIMITATIONS ASSOCIATED WITH INSTALLING AND MAINTAINING TRAFFIC CONTROL MEASURES.
- ALL THERMOPLASTIC PAVEMENT MARKINGS SHALL BE 90 MILS THICKNESS.
- ALL PAVEMENT MARKINGS SHALL BE THERMOPLASTIC AND INSTALLED ACCORDING TO MOST CURRENT NCDOT STANDARDS.
- TIE PROPOSED PAVEMENT MARKING LINES TO EXISTING PAVEMENT MARKING LINES.

REVISIONS:

#	DATE	DESCRIPTION
1	16-OCT-23	SDP 23-05 / CID 23-01 COMBINED REVIEW
2	14-NOV-23	ISSUED FOR CONSTRUCTION
3	20-MAR-24	REVISED PER OWNER/TEAM COMMENTS
4	11-JUL-24	ADDED PLANS & CIVIL BULLETIN (CID 23-01)
5	4-SEP-24	REVISED PER OWNER/TEAM COMMENTS

CROSLAND
SOUTHEAST

ROADWAY - STRIPING AND SIGNAGE PLAN

PUBLIX AT WALLBROOK AND
WALLBROOK ROADWAY IMPROVEMENTS

Town of Rolesville Project No. SDP 23-05 & CID 23-01

S Main St. / US 401 and Virginia Water Drive

Rolesville, Wake County, North Carolina

NC License: P-1199
ARK
CONSULTING
GROUP PLLC
ENGINEERS & PLANNERS

935-A Conference Dr
Durham, NC 27705
(919) 558-0888
www.arkconsultinggroup.com

9/4/2024

Professional Engineer
NORTH CAROLINA
31970
KRYN C. FABUNDI

Project Manager: BCF

Drawn By: DLC

Checked By: STA


Project Number: 21089 / 22012

Drawing Number: D-1219-CD

Date: October 26, 2023

C2.41

CID

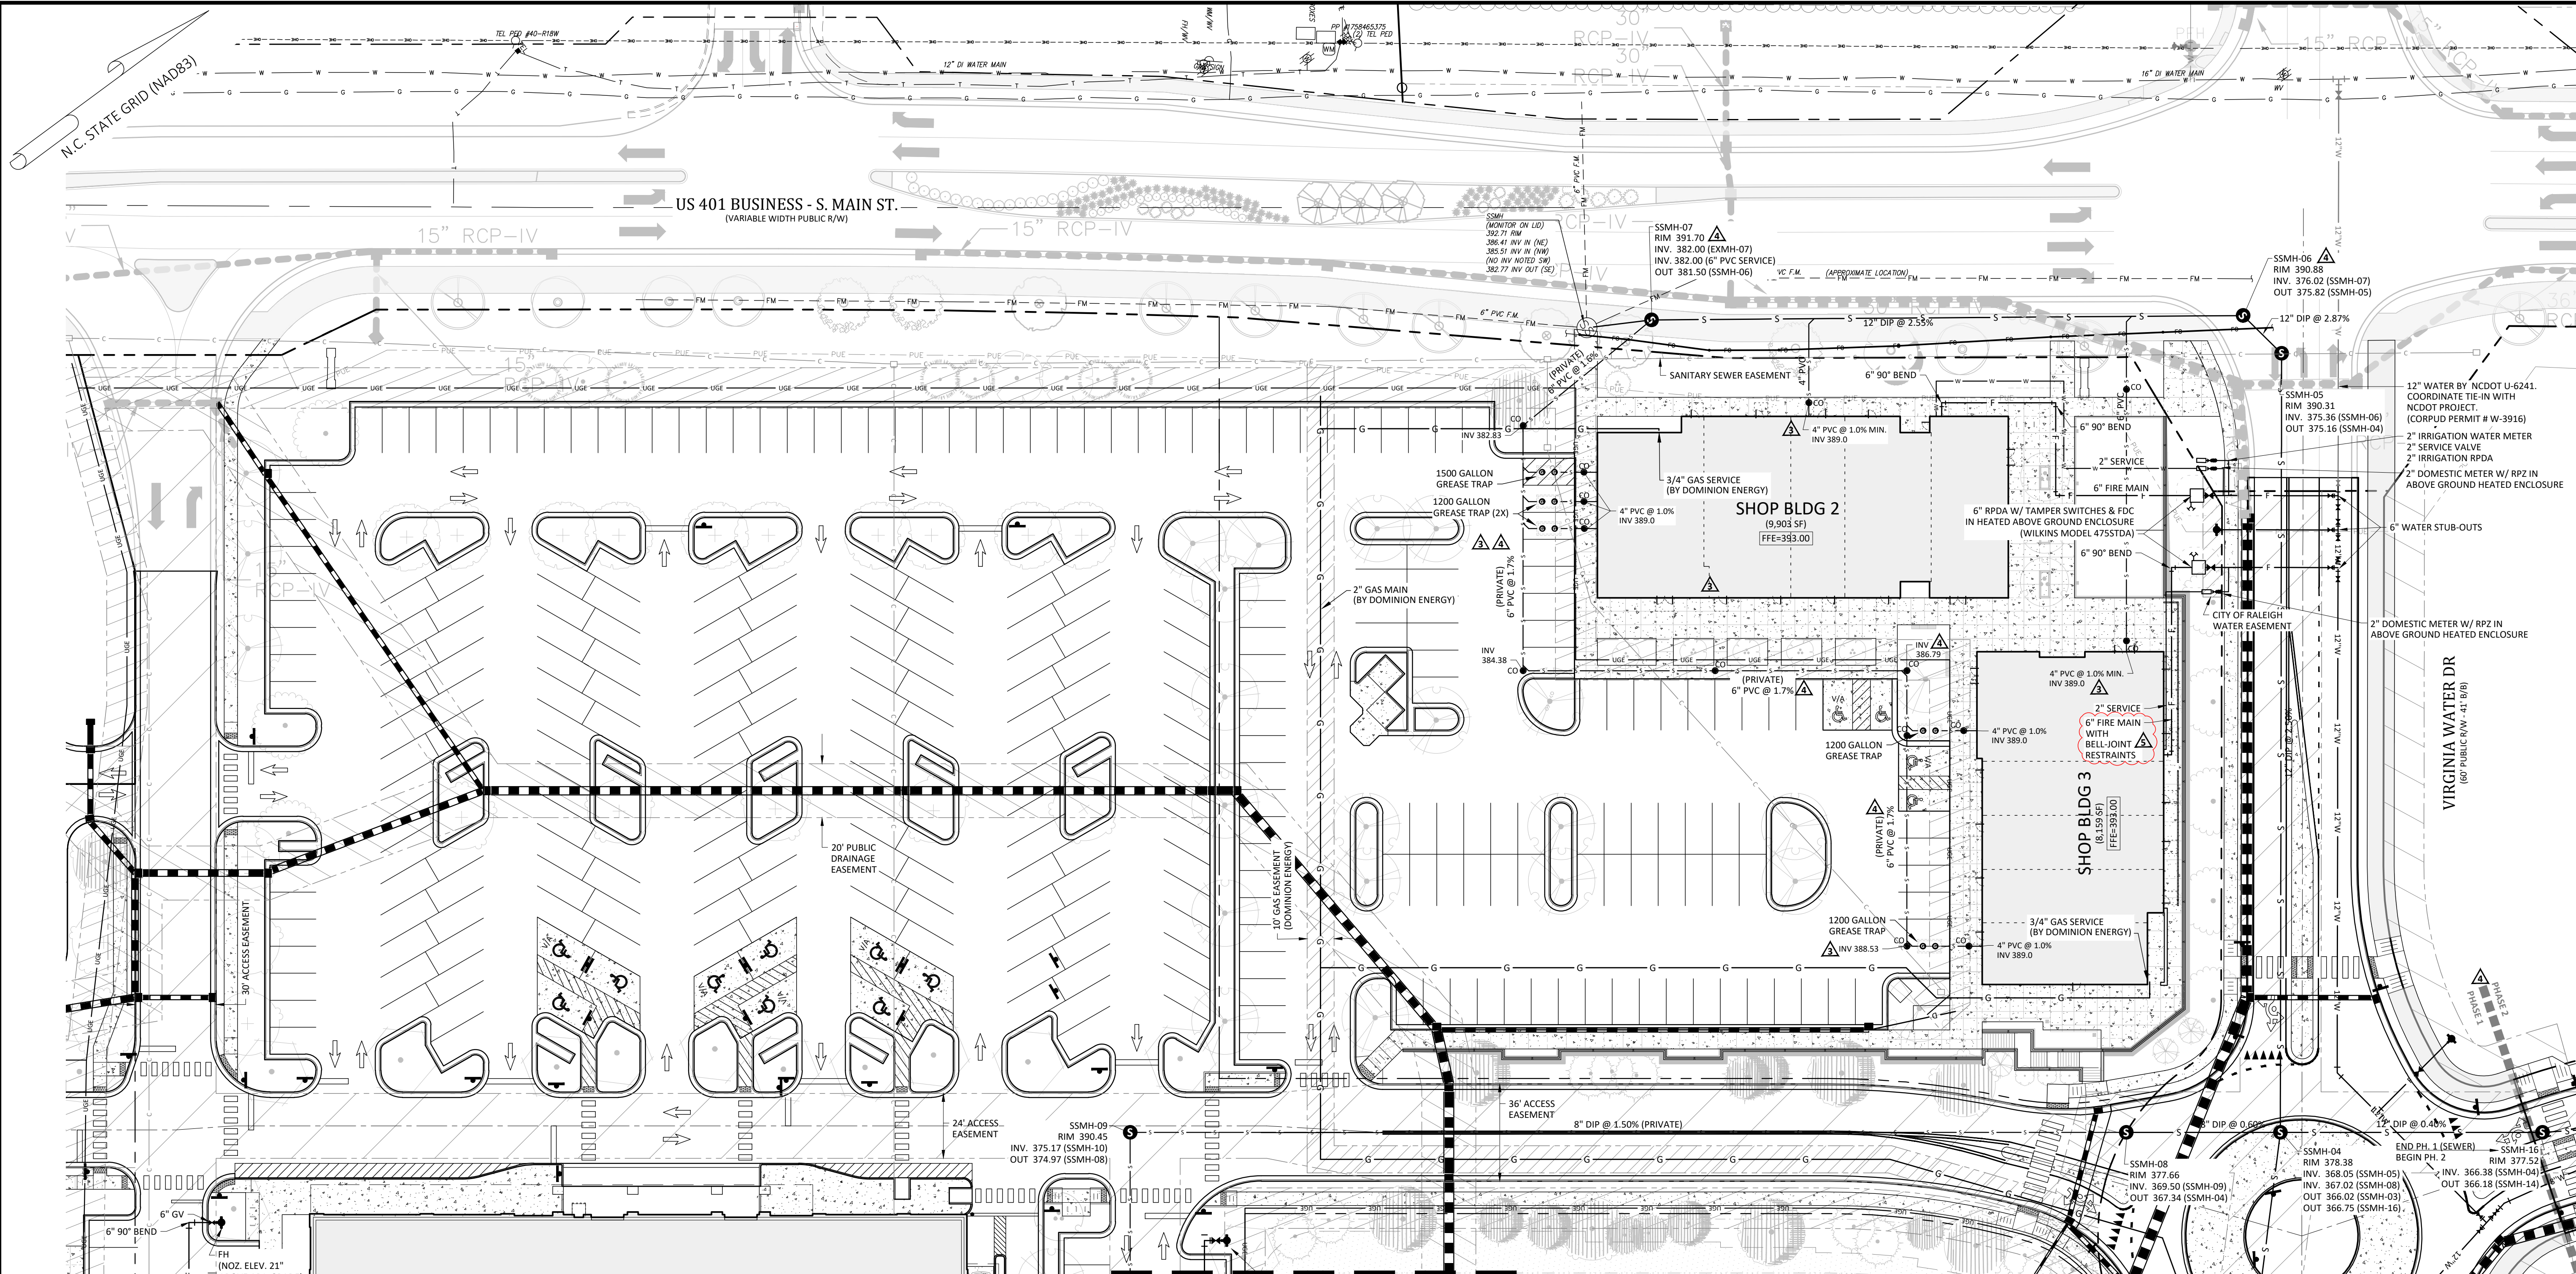

SITE PERMITTING APPROVAL

Water and Sewer Permits (if applicable)

The City of Raleigh consents to the connection and extension of the City's Public Sewer System as shown on this plan. The material and Construction methods used for this project shall conform to the standards and specifications of the City's Public Utilities Handbook. City of Raleigh Public Utilities Department Permit # S-5381

The City of Raleigh consents to the connection and extension of the City's Public Water System as shown on this plan. The material and Construction methods used for this project shall conform to the standards and specifications of the City's Public Utilities Handbook. City of Raleigh Public Utilities Department Permit # WV-4074

The City of Raleigh consents to the connection to its public sewer system and extensions of the private sewer collection system as shown on this plan. The material and construction methods used for this project shall conform to the standards and specifications of the City's Public Utilities Handbook. City of Raleigh Public Utilities Department Permit # S-5380(P)

CITY OF RALEIGH - PLANS AUTHORIZED FOR CONSTRUCTION

Plans for the proposed use have been reviewed for general compliance with applicable codes. This limited review, and authorization for construction is not to be considered to represent total compliance with all legal requirements for development and construction. The property owner, design consultants, and contractors are each responsible for compliance with all applicable City, State and Federal laws. This specific authorization below is not a permit, nor shall it be construed to permit any violation of City, State or Federal Law. All Construction must be in accordance with all Local, State, and Federal Rules and Regulations.

Electronic Approval: This approval is being issued electronically. This approval is valid only upon the signature of a City of Raleigh Review Official below. The City will retain a copy of the approved plans. Any work authorized by this approval must proceed in accordance with the plans kept on file with the City. This electronic approval may not be edited once issued. Any modification to this approval once issued will invalidate this approval.

City of Raleigh Development Approval
City of Raleigh Review Official


ATTENTION CONTRACTORS

The *Construction Contractor* responsible for the extension for water, sewer, and/or reuse, as approved in these plans, is responsible for contacting the **Public Utilities Department at (919) 996-4540** at least **twenty four hours** prior to beginning any of their construction.

Failure to notify both City Departments in advance of beginning construction, will result in the issuance of **monetary fines**, and require reinstatement of any water or sewer facilities not inspected as a result of this notification failure.

Failure to call for **Inspection, Install a Downstream Plug**, have **Permitted Plans** on the **Jobsite**, or any other **Violation of City of Raleigh Standards** will result in a **Fine and Possible Exclusion** from future work in the **City of Raleigh**.

REFERENCE LINE - SEE SHEET C3.20

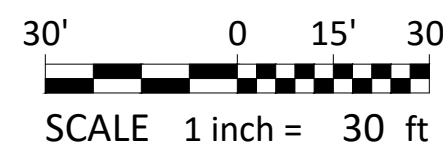

1. 4 SEP 24 REVISED PER OWNER/FEMAN COMMENTS

2. 11 JUL 24 ADDED MANHOLE & CUL BULLET (C3.04) REVISIONS

3. 20 MAR 24 REVISED PER OWNER/FEMAN COMMENTS

4. 14 NOV 23 ISSUED FOR CONSTRUCTION

1. 26 OCT 23 SDP 23-05 / CID 23-01 COMBINED REVIEW

REVISIONS:

DATE

#

CROSLAND
SOUTHEAST

UTILITY PLAN 'A'

**PUBLIX AT WALLBROOK AND
WALLBROOK ROADWAY IMPROVEMENTS**

Town of Rolesville Project No. SDP 23-05 & CID 23-01

Rolesville, Wake County, North Carolina

S Main St. / US 401 and Virginia Water Drive

NC License: P-1199


**ARK
CONSULTING
GROUP PLLC**

935-A Conference Dr.
Raleigh, NC 27608
(919) 558-0888
www.arkconsultinggroup.com

Project Manager: BCF
Drawn By: DLC
Checked By: STA
Project Number: 21089 / 22012
Drawing Number: D-1219-CD
Date: October 26, 2023

C3.10


SDP

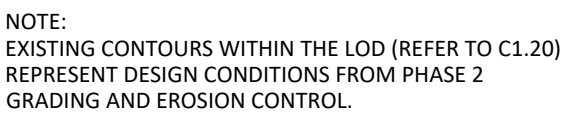


REFERENCE LINE - SEE SHEET C4.20




Outlet	Size (in)	Pad Entry (ft)	Pad Exit (ft)	Pad Length (ft)	Pad Depth (in)	Stone Class
100	30	5	10	13	24	I
200	42	7	14	28	48	I
300	36	6	12	21	40	I
400	30	5	10	13	24	I
500	24	4	8	10	16	I
600	15	3	5	5	7	B

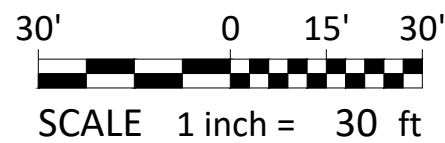

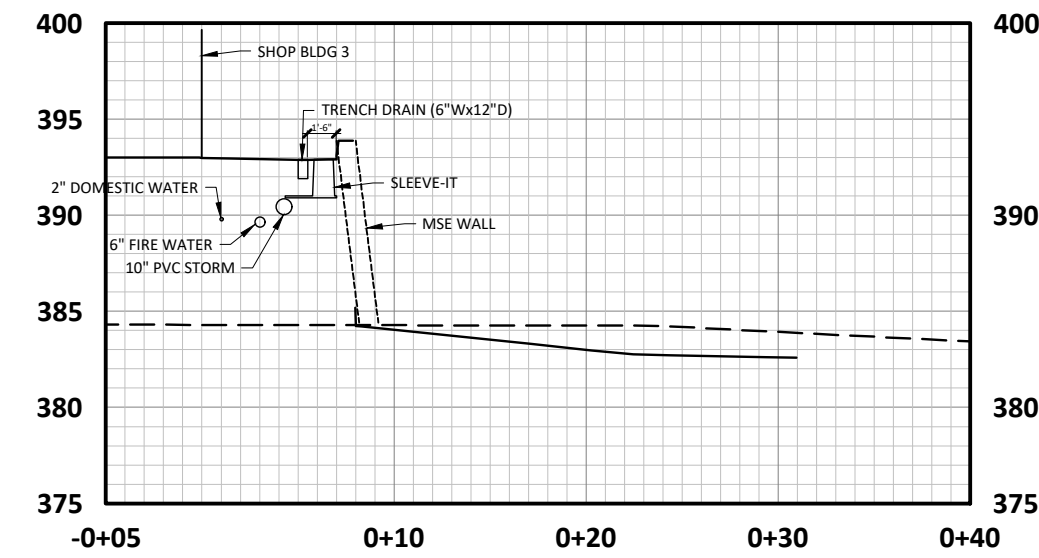

⚠ ENLARGEMENT - PLAN/PROFILE SHOP BLDG 3 TRENCH DRAIN

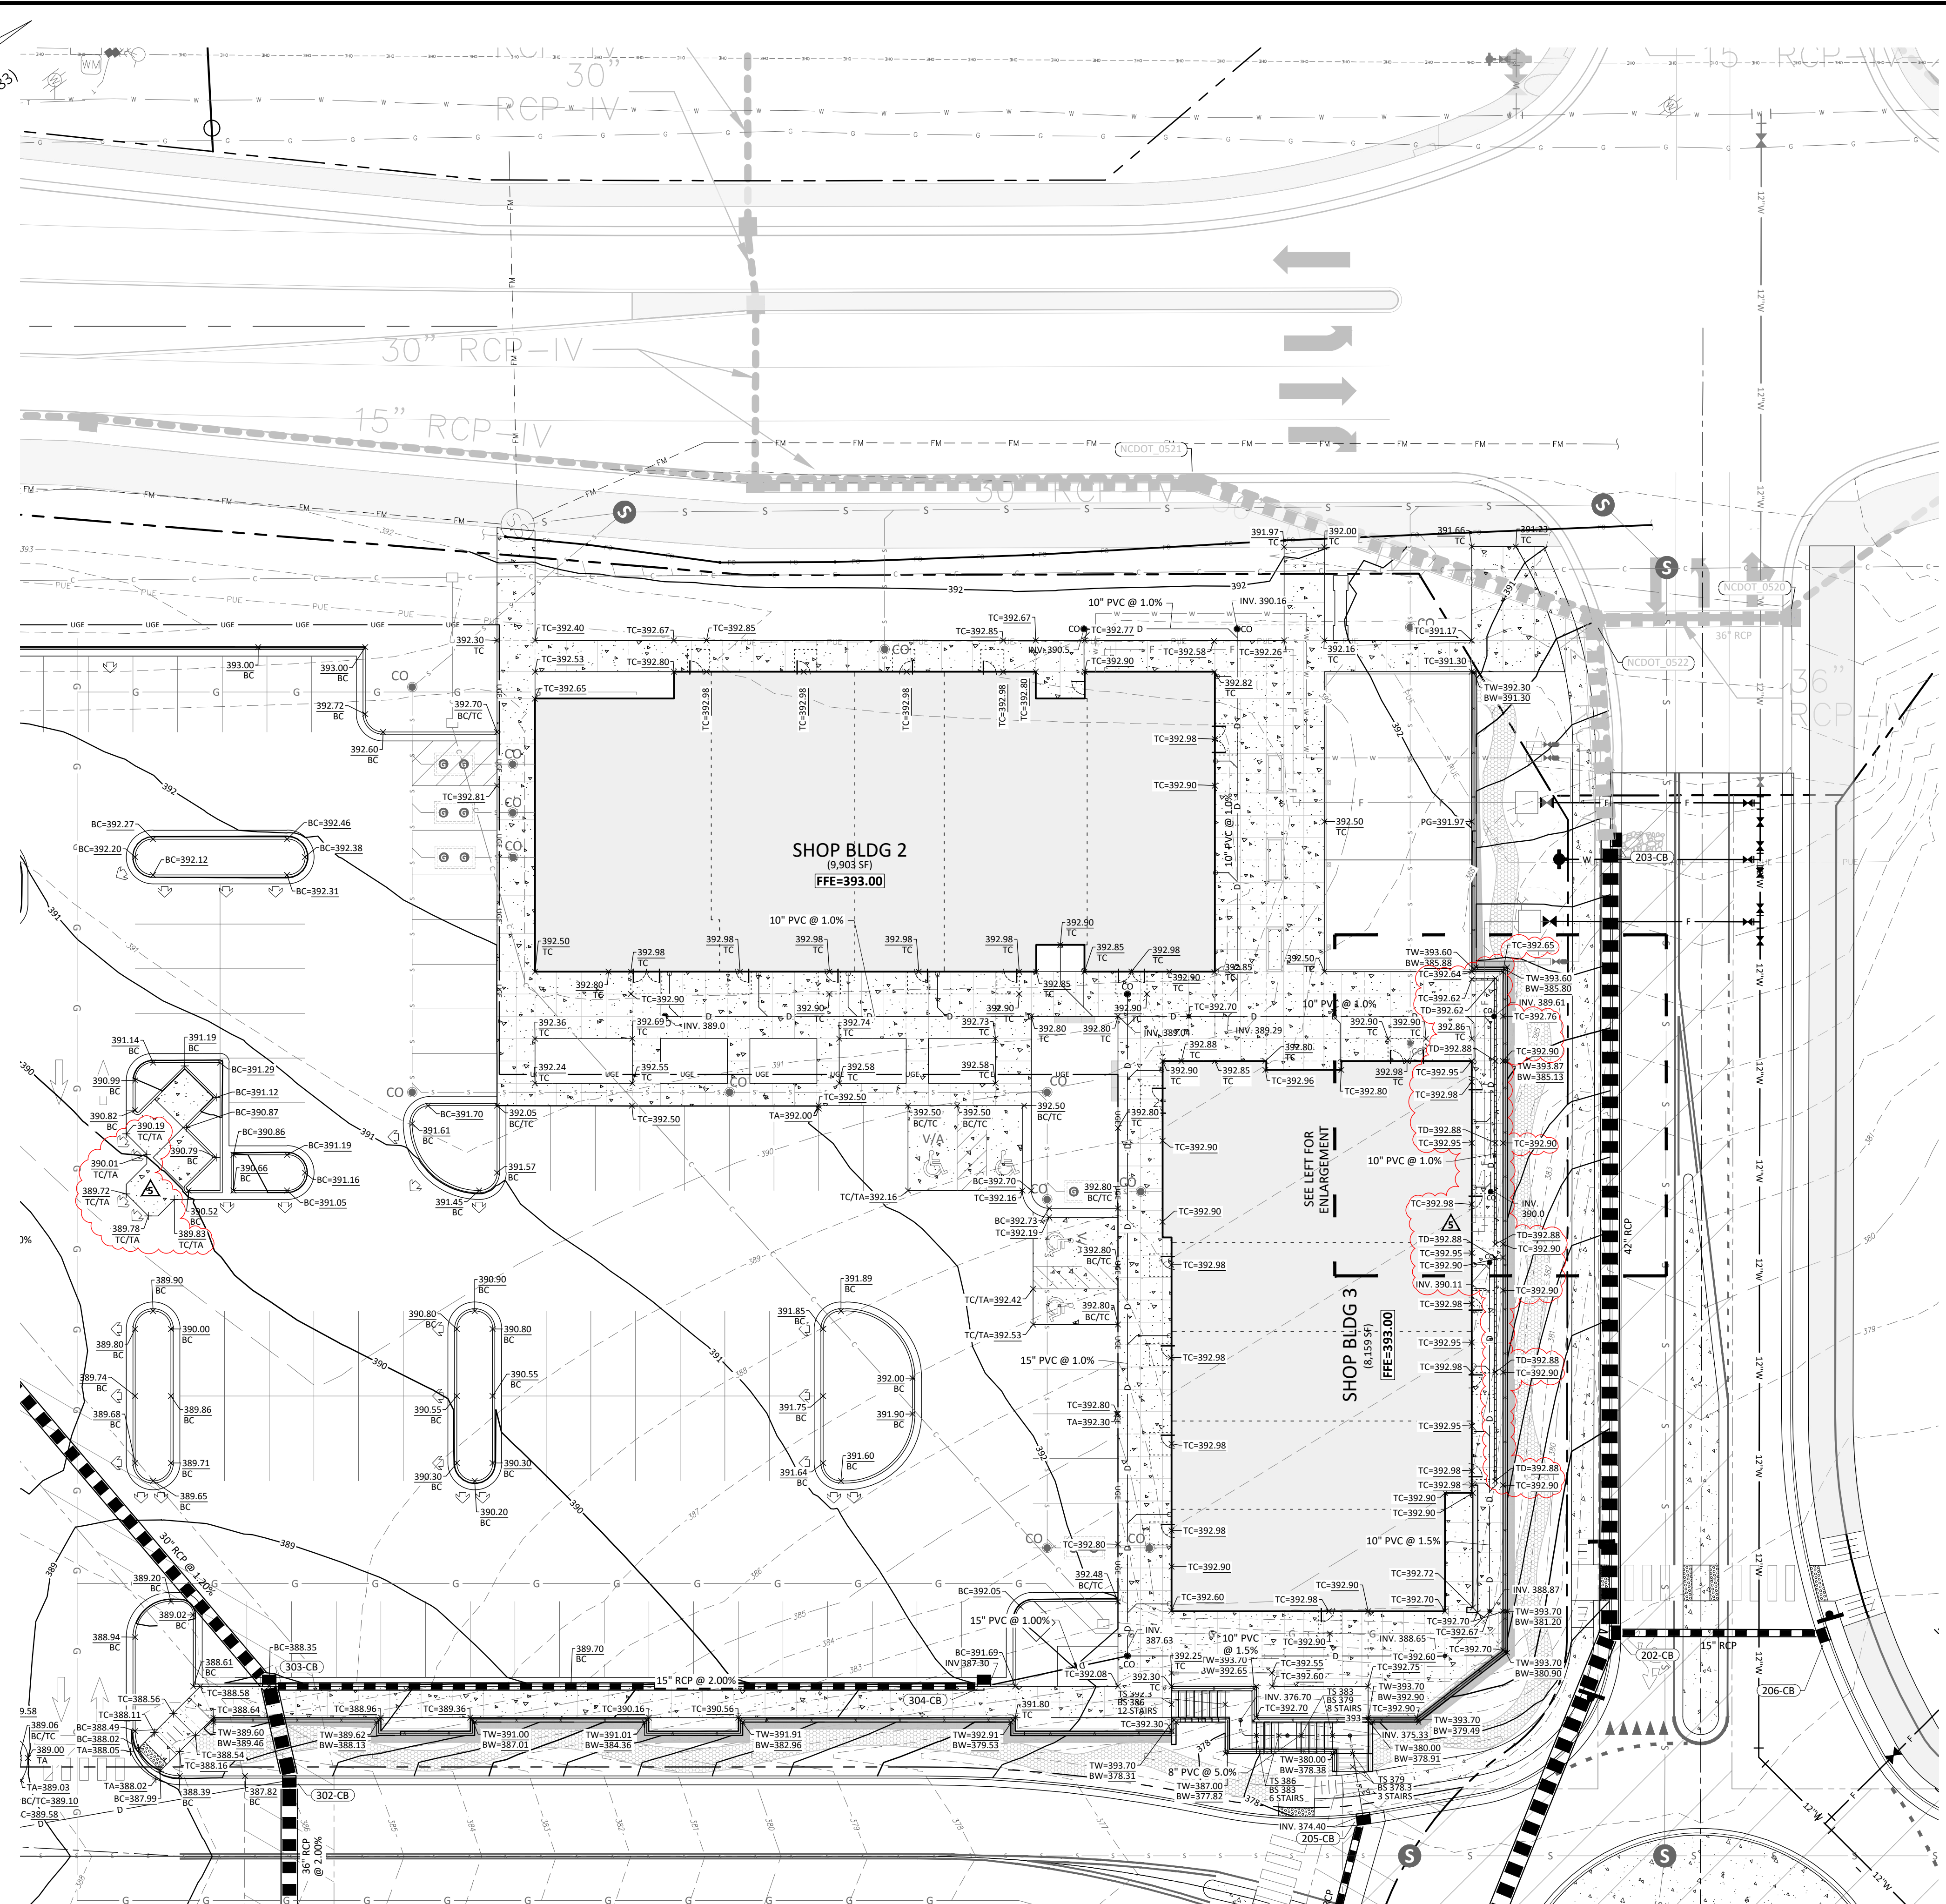

NOTE:
EXISTING CONTOURS WITHIN THE LOD (REFER TO C1.20)
REPRESENT DESIGN CONDITIONS FROM PHASE 2
GRADING AND EROSION CONTROL.

C4.11

SDP

GRADING & DRAINAGE PLAN A - ENLARGEMENT I

PUBLIX AT WALLBROOK AND WALLBROOK ROADWAY IMPROVEMENTS

Town of Rolesville Project No. SDP 23-05 & CID 23-01

S Main St. / US 401 and Virginia Water Drive

Rolesville, Wake County, North Carolina



CROSLAND
SOUTHEAST

#	DATE	DESCRIPTION
1	26-OCT-23	ISSUED 23-05 / CID 23-01 COMBINED REVIEW
2	14-NOV-23	ISSUED FOR OWNER/TENANT COMMENTS
3	20-MAR-24	REVISED PER OWNER/TENANT COMMENTS
4	11-JUL-24	ADDED PHASING & CIVIL BULLETIN (CB-03) REVISIONS
5	4-SEP-24	REVISED PER OWNER/TENANT COMMENTS

ARK CONSULTING GROUP, PLLC
ENGINEERS & PLANNERS
NC license: P-11199


ARK
ENGINEERING

25-A Conference Dr.
Greenville, NC 27858
252) 558-0888
www.arkconsultinggroup.com

Project Manager:	BCF
Drawn By:	DLC
Checked By:	STA
Project Number:	21089 / 22012
Drawing Number:	D-1219-CD
Date:	October 26, 2023



REFERENCE LINE - SEE SHEET C4.10

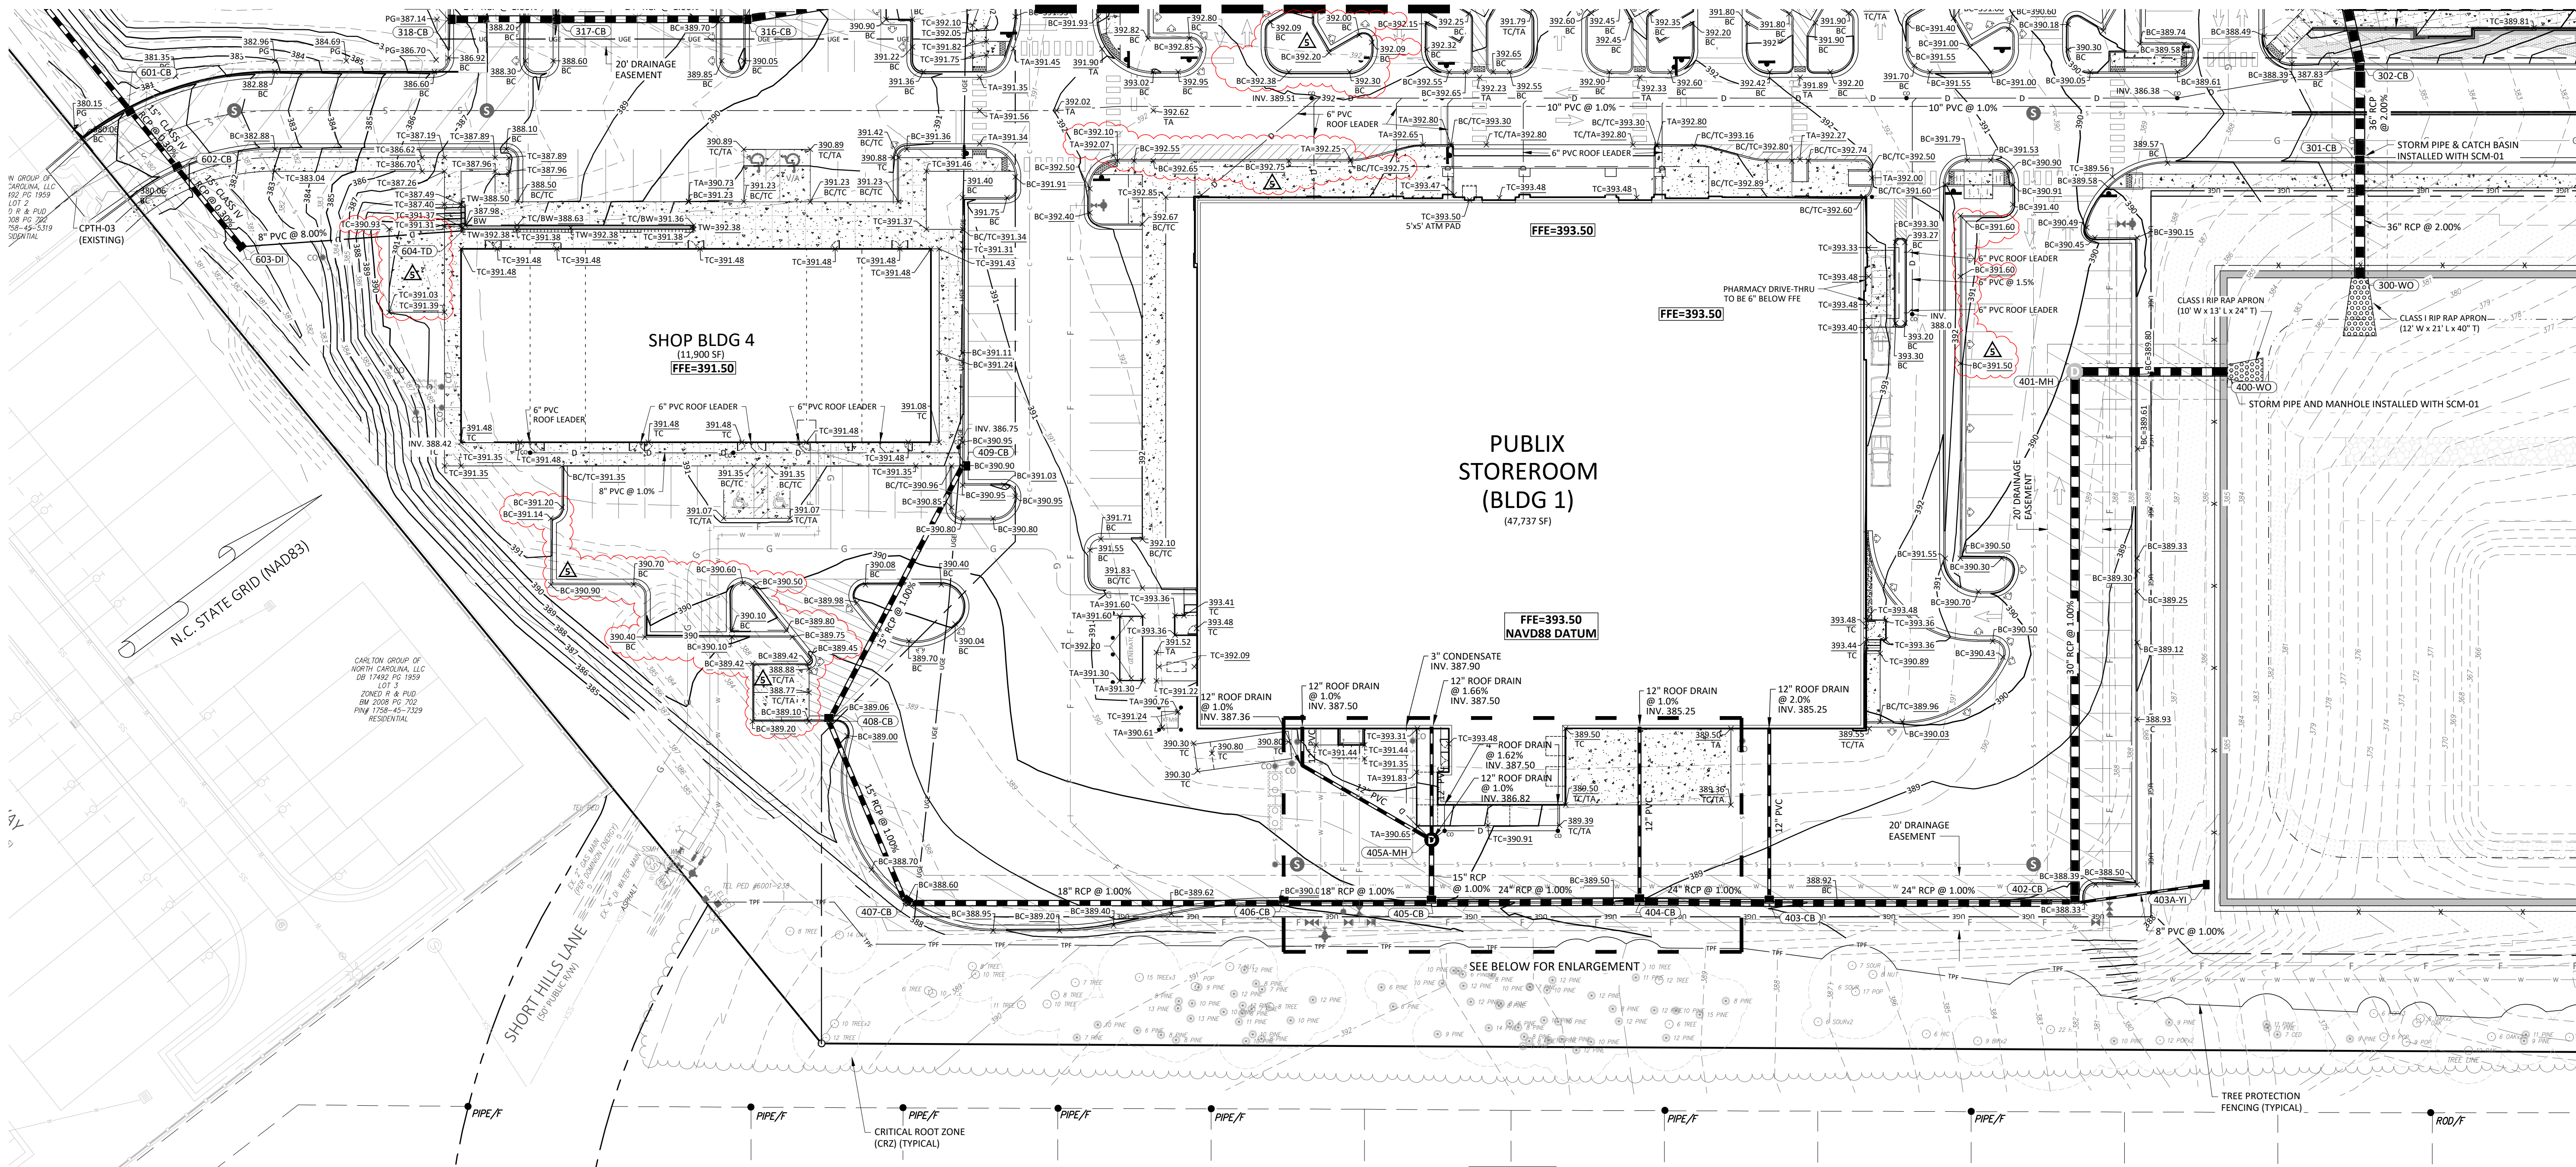

Rip Rap Aprons


Outlet	Size (in)	Pad Entry (ft)	Pad Exit (ft)	Pad Length (ft)	Pad Depth (in)	Stone Class
100	30	5	10	13	24	I
200	42	7	14	28	48	I
300	36	6	12	21	40	I
400	30	5	10	13	24	I
500	24	4	8	10	16	I
600	15	3	5	5	7	B

ID	TOP	IN	OUT	DESC
400-WO	365.55	362.60 (401-MH)		Wall Outlet
401-MH	389.89	377.49 (402-CB)	363.43 (400-WO)	60 in MH
402-CB	388.30	379.91 (403-CB)	379.41 (401-MH)	Catch Basin
403-CB	389.10	381.24 (403A-YI)		Catch Basin
404-CB	389.32	381.02 (404-CB)	381.02 (402-CB)	Catch Basin
405-CB	390.60	386.55 (405A-MH)	382.24 (404-CB)	Catch Basin
405A-MH	390.43	386.82 (RD-5)	386.82 (405-CB)	48 in MH
406-CB	390.05	383.27 (407-CB)	383.27 (405-CB)	Catch Basin
407-CB	388.60	384.89 (408-CB)	384.64 (406-CB)	Catch Basin
408-CB	389.07	385.61 (409-CB)	385.61 (407-CB)	Catch Basin
409-CB	390.90		386.65 (408-CB)	Catch Basin

ID	TOP	IN	OUT	DESC
600-FES	378.37	376.85 (601-CB)		15" Flared End
601-CB	380.53	377.60 (602-CB)	377.60 (600-FES)	Catch Basin
602-CB	380.80	377.69 (603-DI)	377.69 (601-CB)	Catch Basin
603-DI	380.50	377.90 (604-TD)	377.80 (602-CB)	Drop Inlet

ID	TOP	IN	OUT	DESC
300-WO	366.12	362.60 (301-CB)		Wall Outlet
301-CB	387.38	366.40 (302-CB)	363.43 (300-WO)	Catch Basin
302-CB	387.46	371.30 (303-CB)	367.12 (301-CB)	Catch Basin

NOTE:
EXISTING CONTOURS WITHIN THE LOD (REFER TO C1.20)
REPRESENT DESIGN CONDITIONS FROM PHASE 2
GRADING AND EROSION CONTROL.

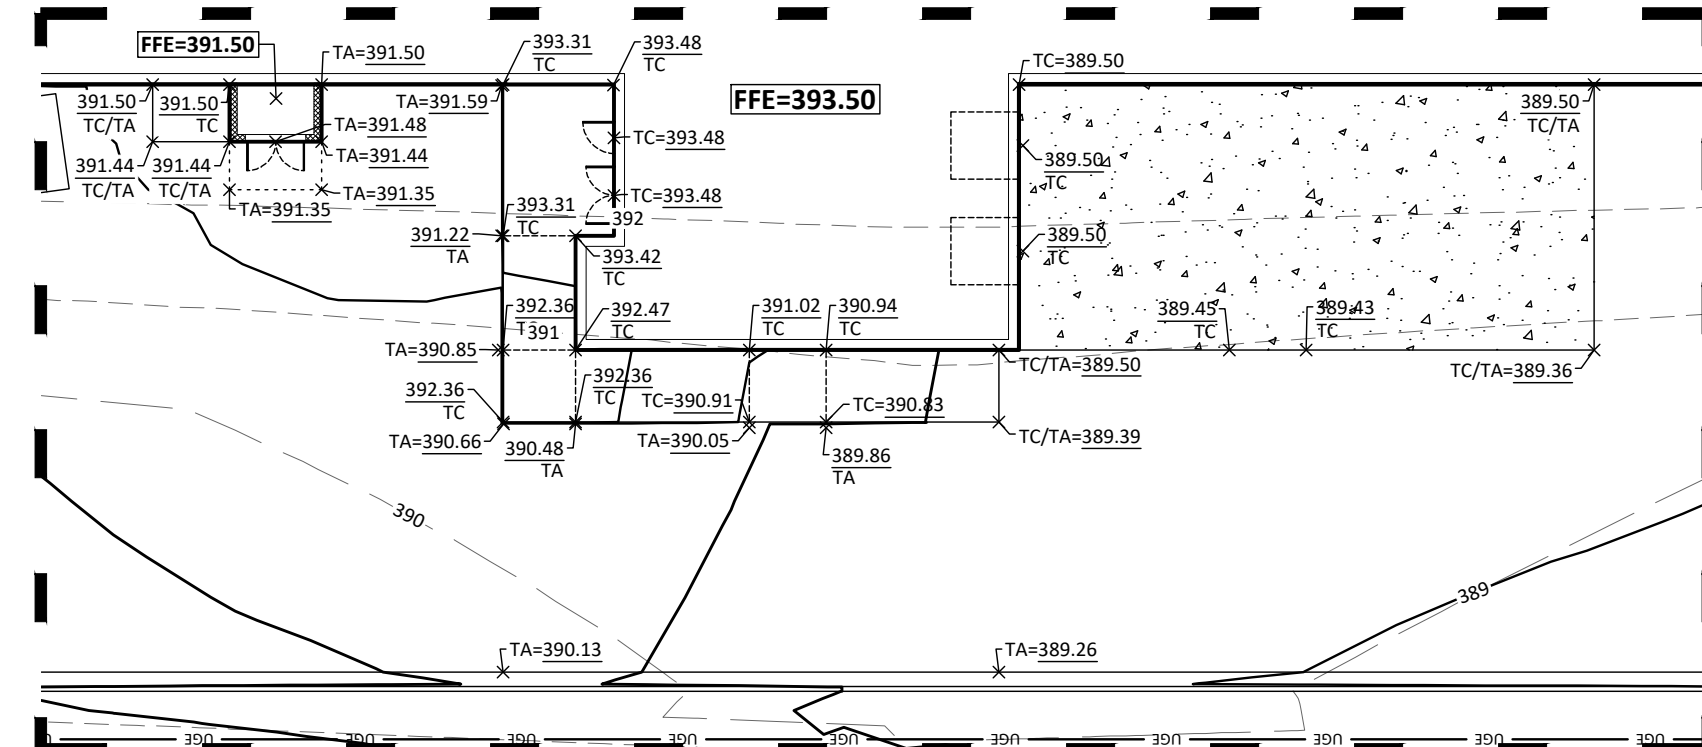

ENLARGEMENT - SERVICE AREA RAMP / RISER ROOM / GREASE BARREL PAD

SCALE: 1" = 20'



KNOW WHAT'S BELOW
CALL BEFORE YOU DIG!
1-800-452-4444
WWW.811.ORG

GRADING & DRAINAGE PLAN 'B'

PUBLIX AT WALLBROOK AND WALLBROOK ROADWAY IMPROVEMENTS Town of Rolesville Project No. SDP 23-05 & CID 23-01

S Main St. / US 401 and Virginia Water Drive
Rolesville, Wake County, North Carolina

NC License: P-1199

ARK CONSULTING GROUP PLLC

ENGINEERS & PLANNERS

935-A Conference Dr.
Rolesville, NC 27588
(252) 558-0888
www.arkconsultinggroup.com

9/4/2024

Professional Engineer
NORTH CAROLINA
31970
DAVID N. C. FABRIZIO

Project Manager: BCF
Drawn By: DLC
Checked By: STA
Project Number: 21089 / 22012
Drawing Number: D-1219-CD
Date: October 26, 2023

C4.20
SDP



REVISIONS:


#	DATE	DESCRIPTION
1	4-SEP-24	REVISED PER OWNER/TEAM COMMENTS
2	11-JUL-24	ADDED MARKS & CUL. BULLET (C4.20) REVISIONS
3	20-MAR-24	REVISED PER OWNER/TEAM COMMENTS
2	14-NOV-23	ISSUED FOR CONSTRUCTION
1	16-OCT-23	SDP 23-05 / CID 23-01 COMBINED REVIEW



NOTE:
EXISTING CONTOURS WITHIN THE LOD (REFER TO C1.20)
REPRESENT DESIGN CONDITIONS FROM PHASE 2
GRADING AND EROSION CONTROL.

STRUCTURE TABLE				
ID	TOP	IN	OUT	DESC
600-FES	378.37	376.85 (601-CB)		15" Flared End
601-CB	380.53	377.60 (602-CB)	377.60 (600-FES)	Catch Basin
602-CB	380.80	377.69 (603-DI)	377.69 (601-CB)	Catch Basin
603-DI	380.50	377.90 (604-TD)	377.80 (602-CB)	Drop Inlet

STRUCTURE TABLE				
ID	TOP	IN	OUT	DESC
300-WO	366.12	362.60 (301-CB)		Wall Outlet
301-CB	387.38	366.40 (302-CB)	363.43 (300-WO)	Catch Basin
302-CB	387.46	371.30 (303-CB)	367.12 (301-CB)	Catch Basin
303-CB	388.35	371.95 (305-CB)	371.55 (302-CB)	Catch Basin
304-CB	391.55	387.30 (304A-CO)	386.30 (303-CB)	Catch Basin
305-CB	388.20	373.34 (306-CB)	373.34 (303-CB)	Catch Basin
306-CB	388.50	373.42 (307-CB)	373.42 (305-CB)	Catch Basin
307-CB	390.53	374.78 (308-CB)	374.78 (306-CB)	Catch Basin
308-CB	390.56	381.90 (309-CB)	376.67 (307-CB)	Catch Basin
309-CB	392.90	384.75 (NCDOT_0417)	384.75 (308-CB)	Catch Basin
310-CB	391.65	378.11 (311-CB)	378.11 (308-CB)	Catch Basin
311-CB	391.47	378.69 (314-CB)	378.69 (310-CB)	Catch Basin
312-CB	391.36	380.25 (313-CB)	380.25 (311-CB)	Catch Basin
313-CB	391.32	380.59 (313A-CB)	380.59 (312-CB)	Catch Basin
313A-CB	390.80		380.70 (313-CB)	Catch Basin
314-CB	391.81	379.24 (316-CB)	379.24 (311-CB)	Catch Basin
315-CB	391.66		386.66 (314-CB)	Catch Basin
316-CB	389.88	380.24 (317-CB)	380.24 (314-CB)	Catch Basin
317-CB	388.44	380.93 (318-CB)	380.93 (316-CB)	Catch Basin
318-CB	387.30		381.31 (317-CB)	Catch Basin
NCDOT_0416	387.52		385.58 (NCDOT_0417)	Catch Basin
NCDOT_0417	387.32	385.38 (NCDOT_0416)		Catch Basin

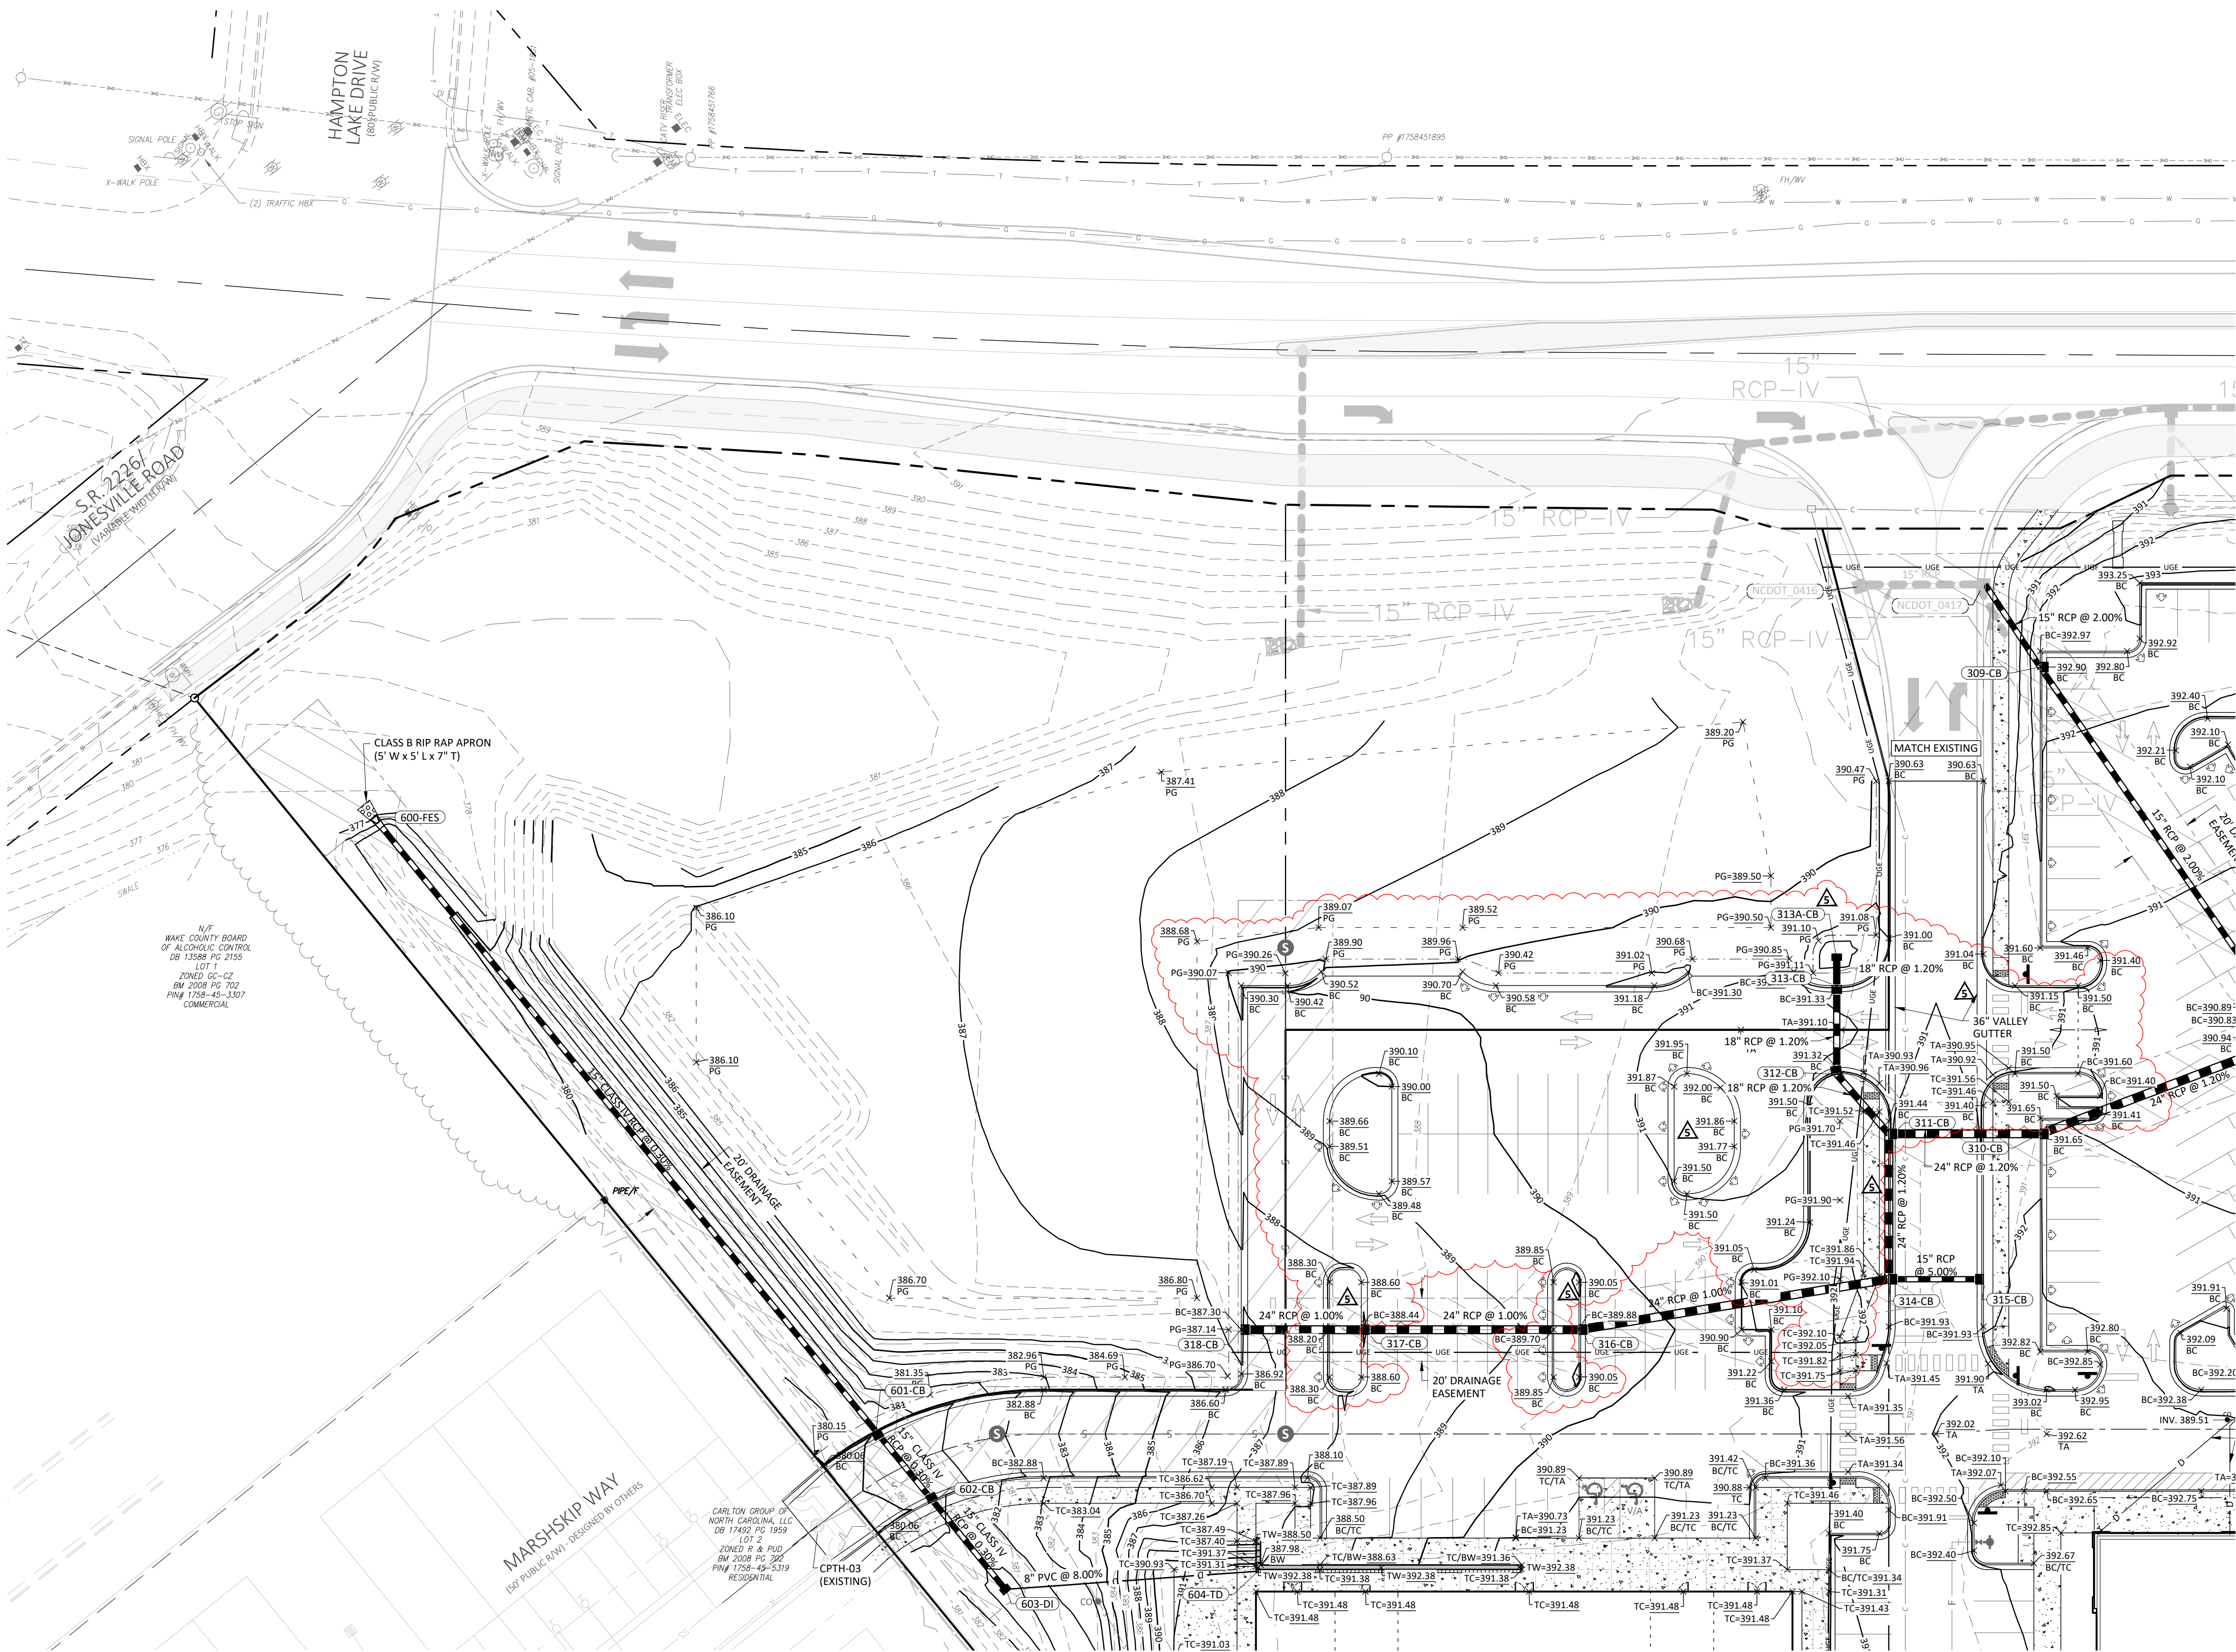

REVISIONS:	
#	DATE
1	14-SEP-24
2	11-OCT-24
3	20-MAR-24
4	11-JUL-24
5	14-NOV-23
6	14-NOV-23
7	14-NOV-23
100	14-NOV-23

CROSLAND
SOUTHEAST

GRADING & DRAINAGE PLAN - OUTPARCELS

PUBLIX AT WALLBROOK AND
WALLBROOK ROADWAY IMPROVEMENTS

Town of Rolesville Project No. SDP 23-05 & CID 23-01

S Main St. / US 401 and Virginia Water Drive

Rolesville, Wake County, North Carolina

ARK
CONSULTING
GROUP PLLC


935-A Conference Dr.
Durham, NC 27603
(919) 488-0888
www.arkconsultinggroup.com

9/4/2024

Project Manager: BCF
Drawn By: DLC
Checked By: STA
Project Number: 21089 / 22012
Drawing Number: D-1219-CD
Date: October 26, 2023

C4.21

SDP

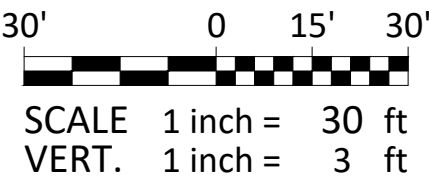

STRUCTURE TABLE				
ID	TOP	IN	OUT	DESC
215-CB	389.44	381.00 (217-CB) 381.00 (216-CB) 380.75 (215A-D)	380.75 (213-CB)	Catch Basin
215A-DI	389.62		381.04 (215-CB)	Drop Inlet
216-CB	389.44		381.82 (215-CB)	Catch Basin
217-CB	390.75	383.38 (218-CB)	383.38 (215-CB)	Catch Basin
218-CB	391.18	384.18 (219-CB)	384.18 (217-CB)	Catch Basin
219-CB	391.62	385.14 (220-CB)	385.14 (218-CB)	Catch Basin
220-CB	391.04	386.61 (221-CB)	386.61 (219-CB)	Catch Basin
221-CB	390.80		387.45 (220-CB)	Catch Basin

5	4-SEP-24	REVISED PER OWNER/TENANT COMMENTS
4	11-JUL-24	ADDED PHASING & CIVIL BULLETIN (CB-03) REVISIONS
3	20-MAR-24	REVISED PER OWNER/TENANT COMMENTS
2	14-NOV-23	ISSUED FOR CONSTRUCTION
1	26-OCT-23	SDP 23-05 / CID 23-01 COMBINED REVIEW
#	DATE	DESCRIPTION



CROSLAND
SOUTHEAST

PLAN-PROFILE - WALLBROOK DRIVE

**PUBlix AT WALLBROOK AND
WALLBROOK ROADWAY IMPROVEMENTS**

Town of Rolesville Project No. SDP 23-05 & CID 23-01


S Main St. / US 401 and Virginia Water Drive
Rolesville, Wake County, North Carolina

Water and Sewer Permits (if applicable)

The City of Raleigh consents to the connection and extension of the City's Public Sewer System as shown on this plan. The material and Construction methods used for this project shall conform to the standards and specifications of the City's Public Utilities Handbook. City of Raleigh Public Utilities Department Permit # W-5381

The City of Raleigh consents to the connection and extension of the City's Public Water System as shown on this plan. The material and Construction methods used for this project shall conform to the standards and specifications of the City's Public Utilities Handbook. City of Raleigh Public Utilities Department Permit # W-4074

The City of Raleigh consents to the connection to its public sewer system and extensions of the private sewer collection system as shown on this plan. The material and construction methods used for this project shall conform to the standards and specifications of the City's Public Utilities Handbook. City of Raleigh Public Utilities Department Permit # W-5380(P)

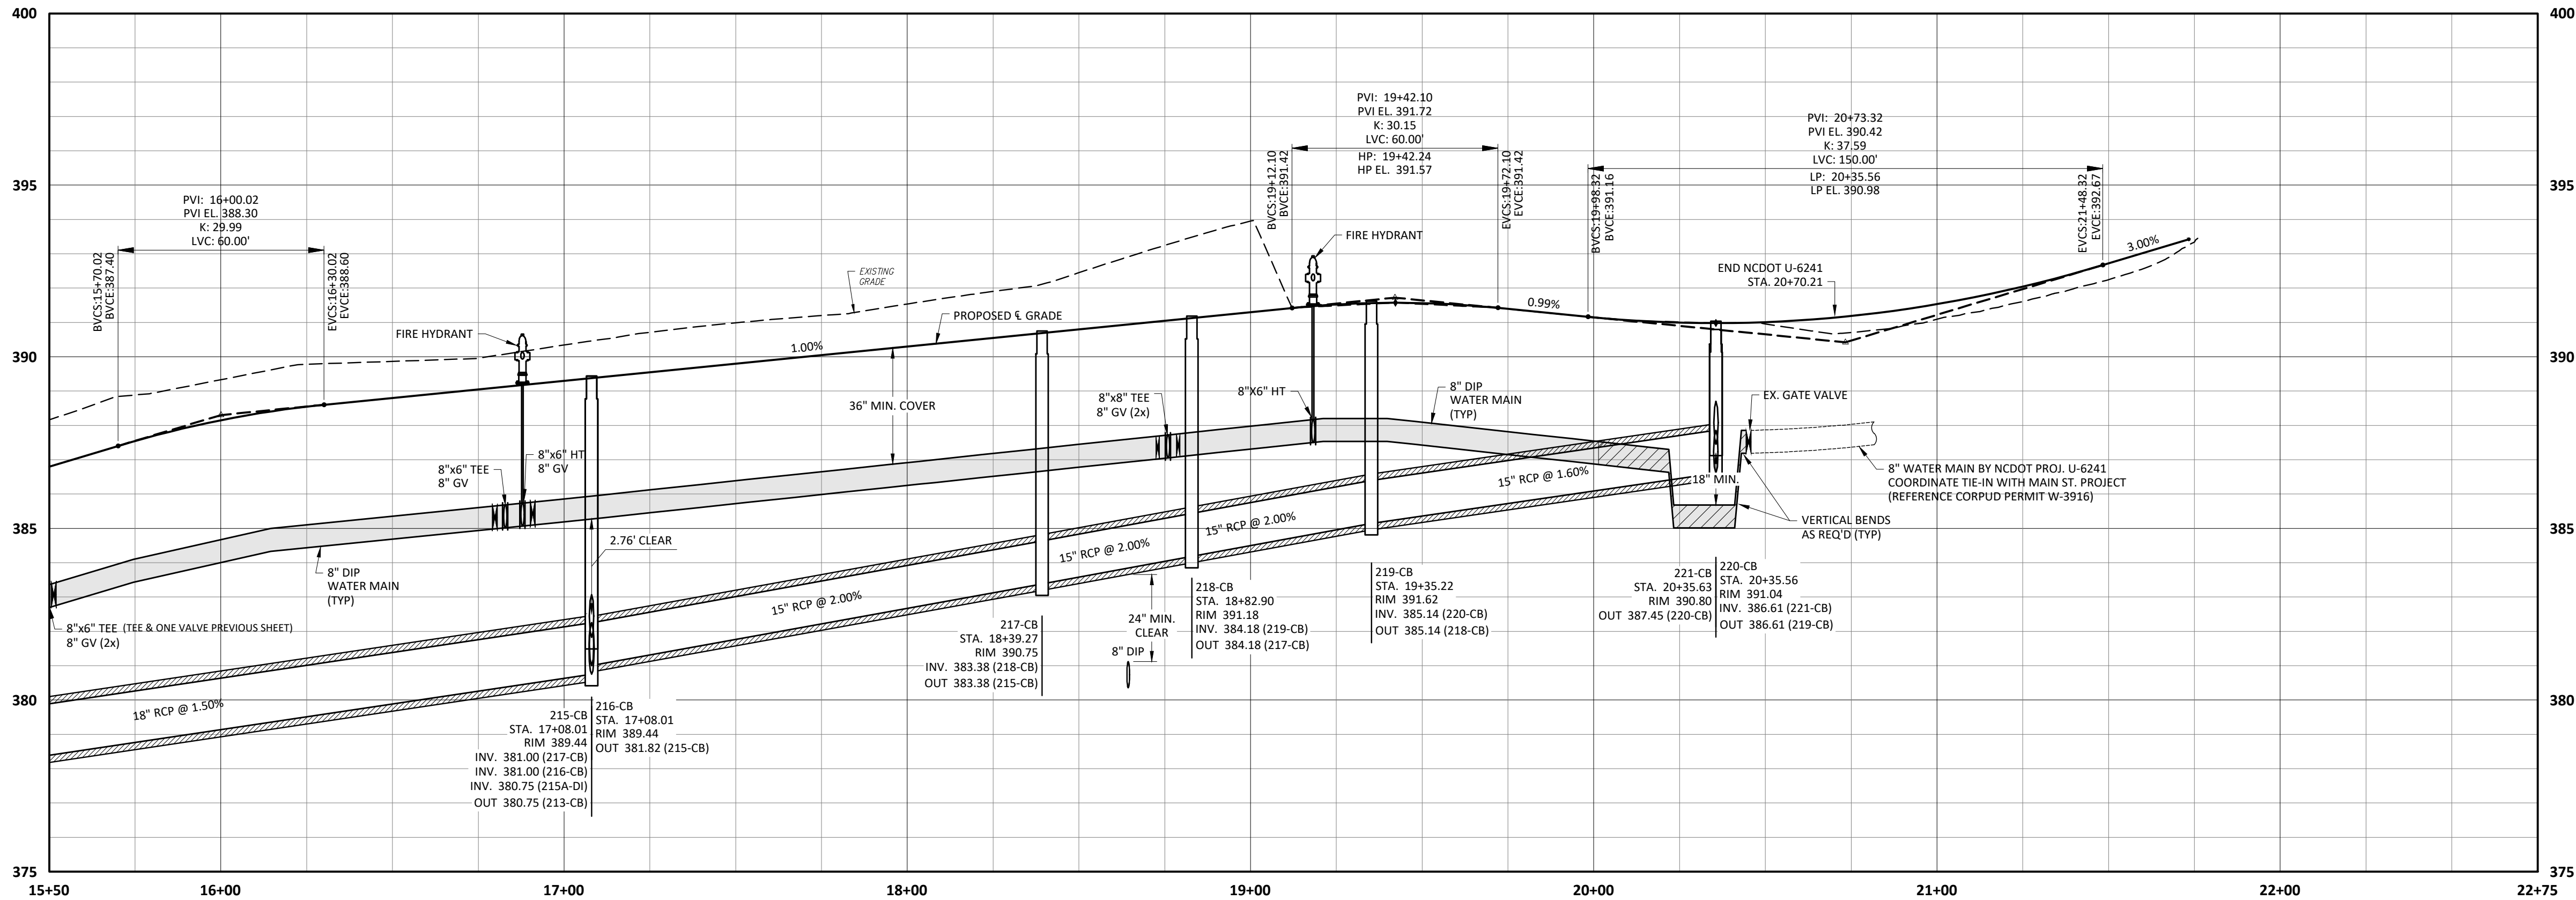

NC License # 11109
ARK CONSULTING GROUP PLLC
ENGINEERS & PLANNERS

935-A Conference Dr.
Greenville, NC 27858
(252) 558-0888
www.arkconsultinggroup.com



Project Manager:	BCF
Drawn By:	DLC
Checked By:	STA
Project Number:	21089 / 22012
Drawing Number:	D-1219-CD
Date:	October 26, 2023

C5.02

CID